





1 Interior Ground Floor Plan
1 : 100

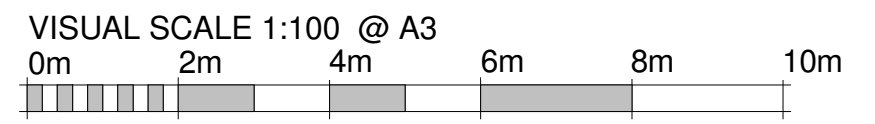

	Team: TEAM UOW Address: UNIVERSITY OF WOLLONGONG WOLLONGONG NSW, AUSTRALIA 2522	Client: Dubai Electricity and Water Authority 	AMENDMENTS				COPYRIGHT None; Project is Public			FLOOR PLAN																			
	Contact: sd-2018@uow.edu.au www.desertrosehouse.com.au		<table border="1"> <thead> <tr> <th>REV.</th> <th>DESCRIPTION</th> <th>DATE</th> <th>DRAWN</th> <th>CHECK</th> </tr> </thead> <tbody> <tr> <td>1</td> <td>Updated Plans, Detailing and Template Adjustments</td> <td>01/02/18</td> <td>JR</td> <td>VP</td> </tr> <tr> <td>2</td> <td>Updated to As-Built</td> <td>14/09/18</td> <td>VP</td> <td>JR</td> </tr> </tbody> </table>	REV.	DESCRIPTION	DATE	DRAWN	CHECK			1	Updated Plans, Detailing and Template Adjustments	01/02/18	JR	VP	2	Updated to As-Built	14/09/18	VP	JR	<table border="1"> <tbody> <tr> <td>LOT</td> <td># M</td> </tr> <tr> <td>DRAWER</td> <td>J.ROTH</td> </tr> <tr> <td>CHECKED</td> <td>V.PHAM</td> </tr> <tr> <td>DATE</td> <td>20 February, 2018</td> </tr> <tr> <td>SCALE</td> <td>1 : 100 @ A3</td> </tr> </tbody> </table>	LOT	# M	DRAWER	J.ROTH	CHECKED	V.PHAM	DATE	20 February, 2018
REV.	DESCRIPTION	DATE	DRAWN	CHECK																									
1	Updated Plans, Detailing and Template Adjustments	01/02/18	JR	VP																									
2	Updated to As-Built	14/09/18	VP	JR																									
LOT	# M																												
DRAWER	J.ROTH																												
CHECKED	V.PHAM																												
DATE	20 February, 2018																												
SCALE	1 : 100 @ A3																												

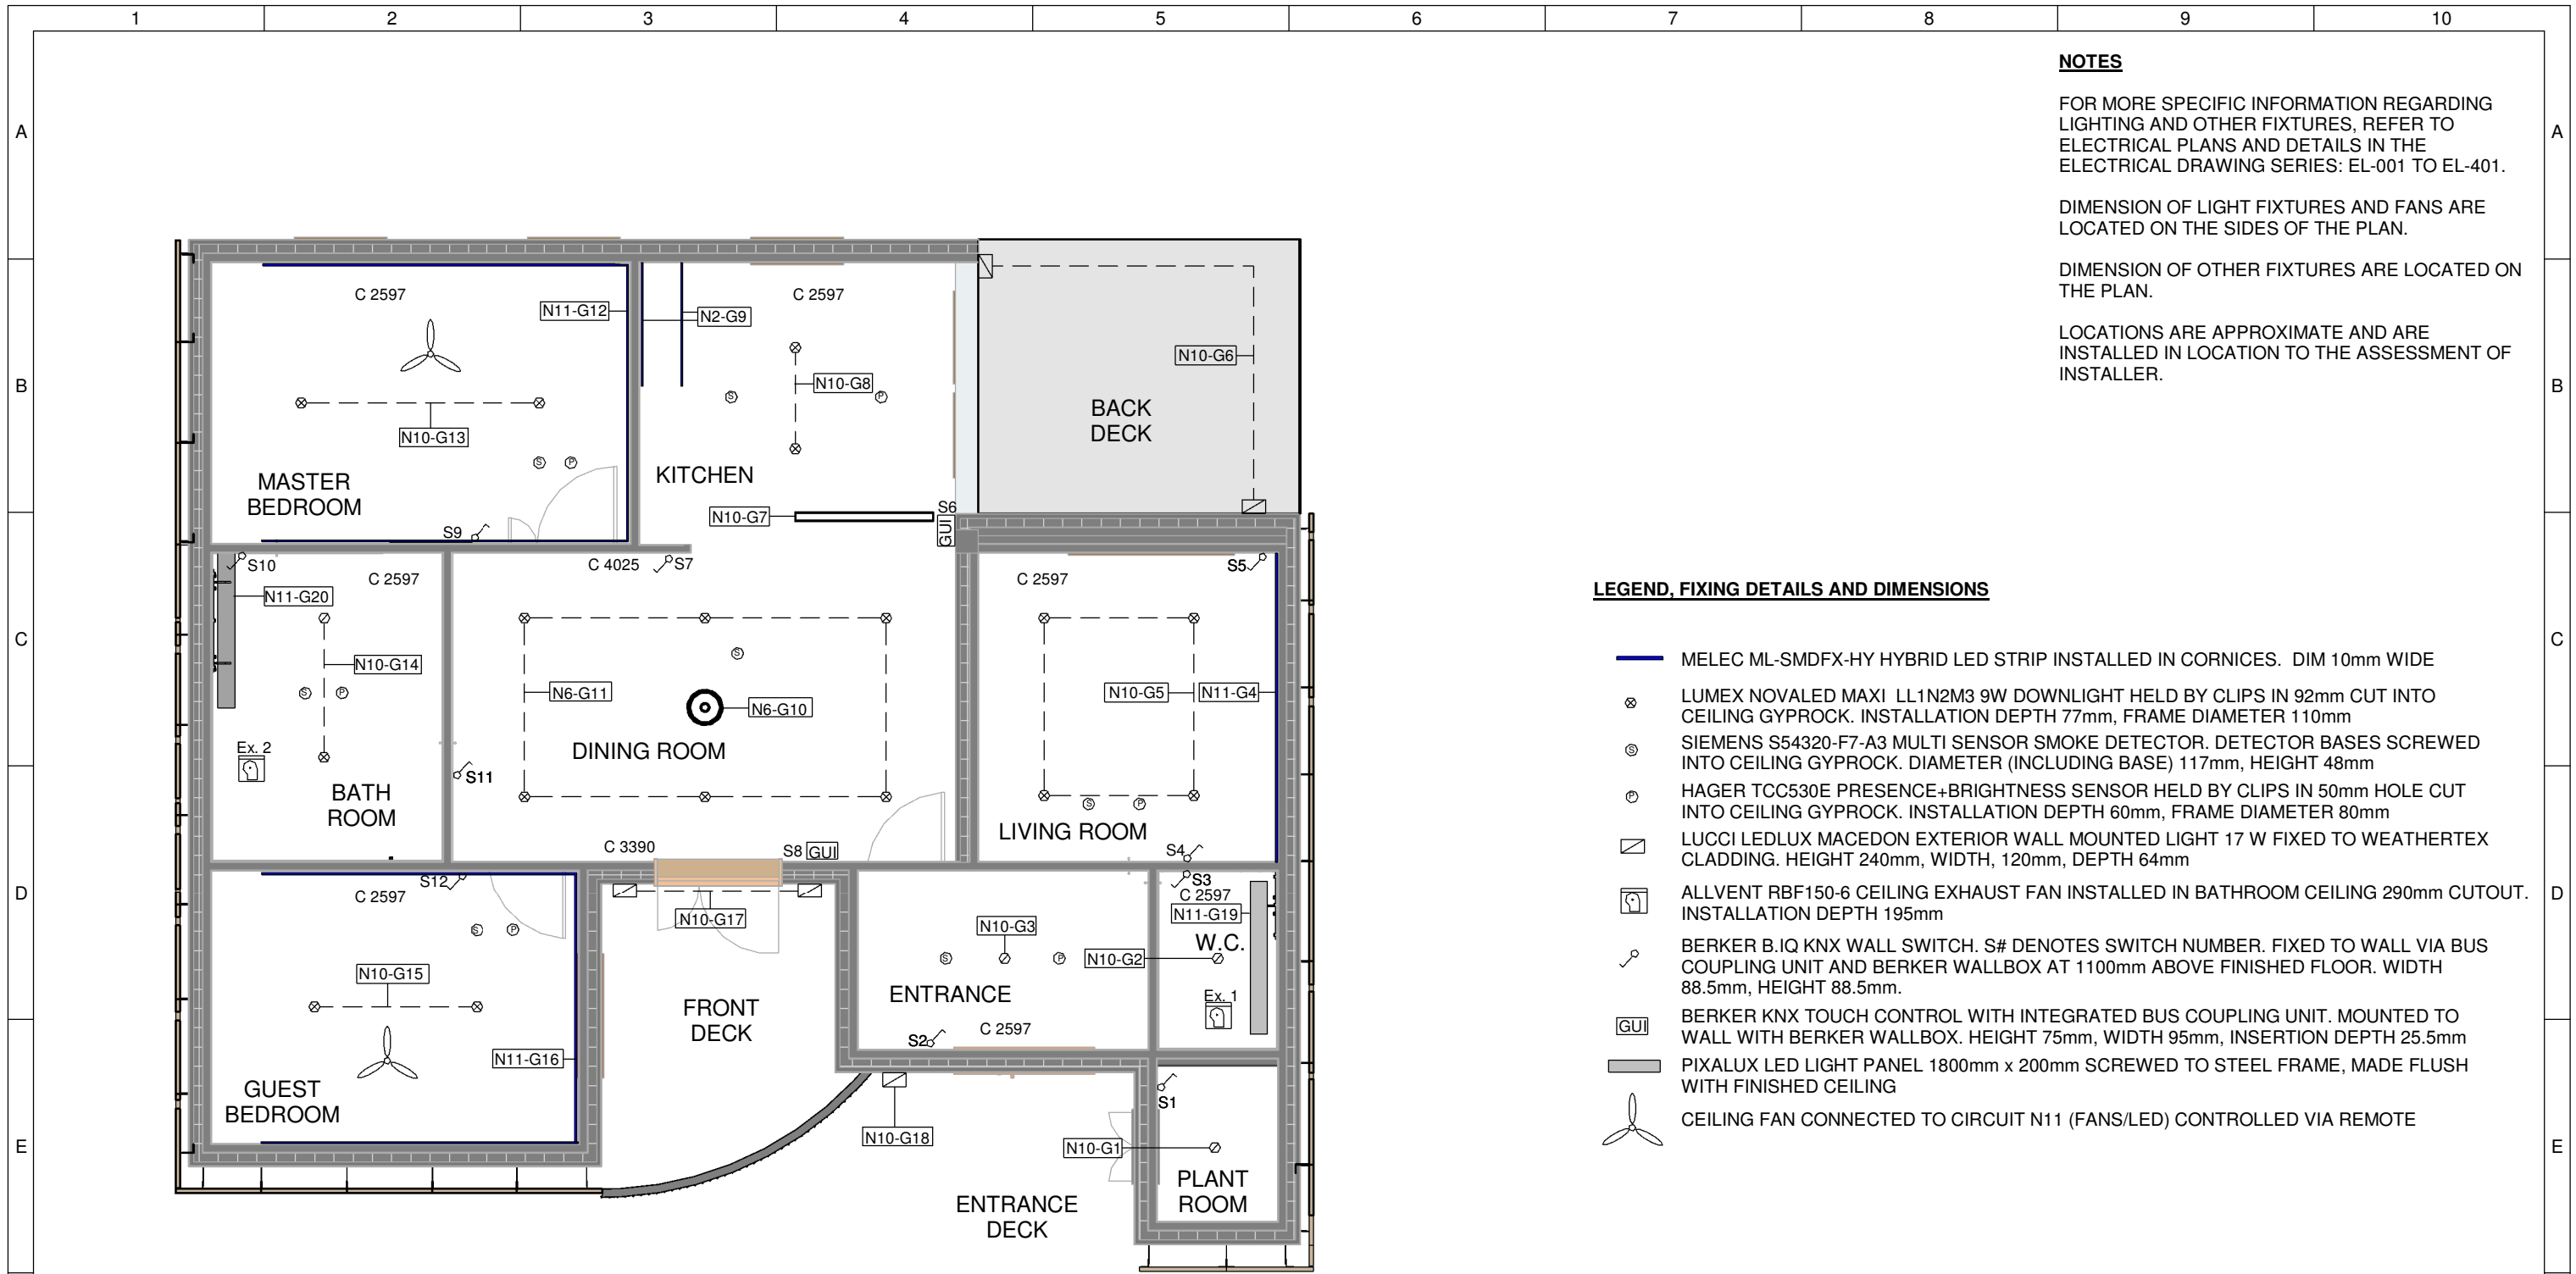

NOTES

FOR MORE SPECIFIC INFORMATION REGARDING LIGHTING AND OTHER FIXTURES, REFER TO ELECTRICAL PLANS AND DETAILS IN THE ELECTRICAL DRAWING SERIES: EL-001 TO EL-401.

DIMENSION OF LIGHT FIXTURES AND FANS ARE LOCATED ON THE SIDES OF THE PLAN.


DIMENSION OF OTHER FIXTURES ARE LOCATED ON THE PLAN.

LOCATIONS ARE APPROXIMATE AND ARE INSTALLED IN LOCATION TO THE ASSESSMENT OF INSTALLER.


LEGEND, FIXING DETAILS AND DIMENSIONS

- MELEC ML-SMDFX-HY HYBRID LED STRIP INSTALLED IN CORNICES. DIM 10mm WIDE
- LUMEX NOVALED MAXI LL1N2M3 9W DOWNLIGHT HELD BY CLIPS IN 92mm CUT INTO CEILING GYPROCK. INSTALLATION DEPTH 77mm, FRAME DIAMETER 110mm
- SIEMENS S54320-F7-A3 MULTI SENSOR SMOKE DETECTOR. DETECTOR BASES SCREWED INTO CEILING GYPROCK. DIAMETER (INCLUDING BASE) 117mm, HEIGHT 48mm
- HAGER TCC530E PRESENCE+BRIGHTNESS SENSOR HELD BY CLIPS IN 50mm HOLE CUT INTO CEILING GYPROCK. INSTALLATION DEPTH 60mm, FRAME DIAMETER 80mm
- LUCCI LEDLUX MACEDON EXTERIOR WALL MOUNTED LIGHT 17 W FIXED TO WEATHERTEX CLADDING. HEIGHT 240mm, WIDTH, 120mm, DEPTH 64mm
- ALLVENT RBF150-6 CEILING EXHAUST FAN INSTALLED IN BATHROOM CEILING 290mm CUTOUT. INSTALLATION DEPTH 195mm
- BERKER B.IQ KNX WALL SWITCH. S# DENOTES SWITCH NUMBER. FIXED TO WALL VIA BUS COUPLING UNIT AND BERKER WALLBOX AT 1100mm ABOVE FINISHED FLOOR. WIDTH 88.5mm, HEIGHT 88.5mm.
- BERKER KNX TOUCH CONTROL WITH INTEGRATED BUS COUPLING UNIT. MOUNTED TO WALL WITH BERKER WALLBOX. HEIGHT 75mm, WIDTH 95mm, INSERTION DEPTH 25.5mm
- PIXALUX LED LIGHT PANEL 1800mm x 200mm SCREWED TO STEEL FRAME, MADE FLUSH WITH FINISHED CEILING
- CEILING FAN CONNECTED TO CIRCUIT N11 (FANS/LED) CONTROLLED VIA REMOTE

1 IN - Reflected Ceiling Plan
1 : 75

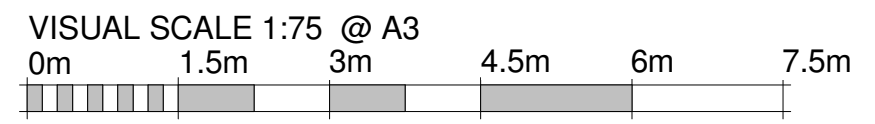


	Team: TEAM UOW Address: UNIVERSITY OF WOLLONGONG WOLLONGONG NSW, AUSTRALIA 2522 Contact: sd-2018@uow.edu.au www.desertrosehouse.com.au	Client: Dubai Electricity and Water Authority 	AMENDMENTS <table border="1"> <thead> <tr> <th>REV.</th> <th>DESCRIPTION</th> <th>DATE</th> <th>DRAWN</th> <th>CHECK</th> </tr> </thead> <tbody> <tr> <td>1</td> <td>Update dimensions and annotation as specified in EL-201</td> <td>14/09/18</td> <td>CE</td> <td>VP</td> </tr> <tr> <td>2</td> <td>Updated to As-Built</td> <td>14/09/18</td> <td>VP</td> <td>JR</td> </tr> </tbody> </table>	REV.	DESCRIPTION	DATE	DRAWN	CHECK	1	Update dimensions and annotation as specified in EL-201	14/09/18	CE	VP	2	Updated to As-Built	14/09/18	VP	JR	COPYRIGHT None; Project is Public LOT # M DRAWER C.EIO CHECKED V.PHAM DATE 20 February, 2018 SCALE 1 : 75 @ A3	 NORTH REFLECTED CEILING PLAN SHEET: 01 OF 01 IN-101
	REV.	DESCRIPTION	DATE	DRAWN	CHECK															
1	Update dimensions and annotation as specified in EL-201	14/09/18	CE	VP																
2	Updated to As-Built	14/09/18	VP	JR																
<p>1 2 3 4 5 6 7 8 9 10</p>																				

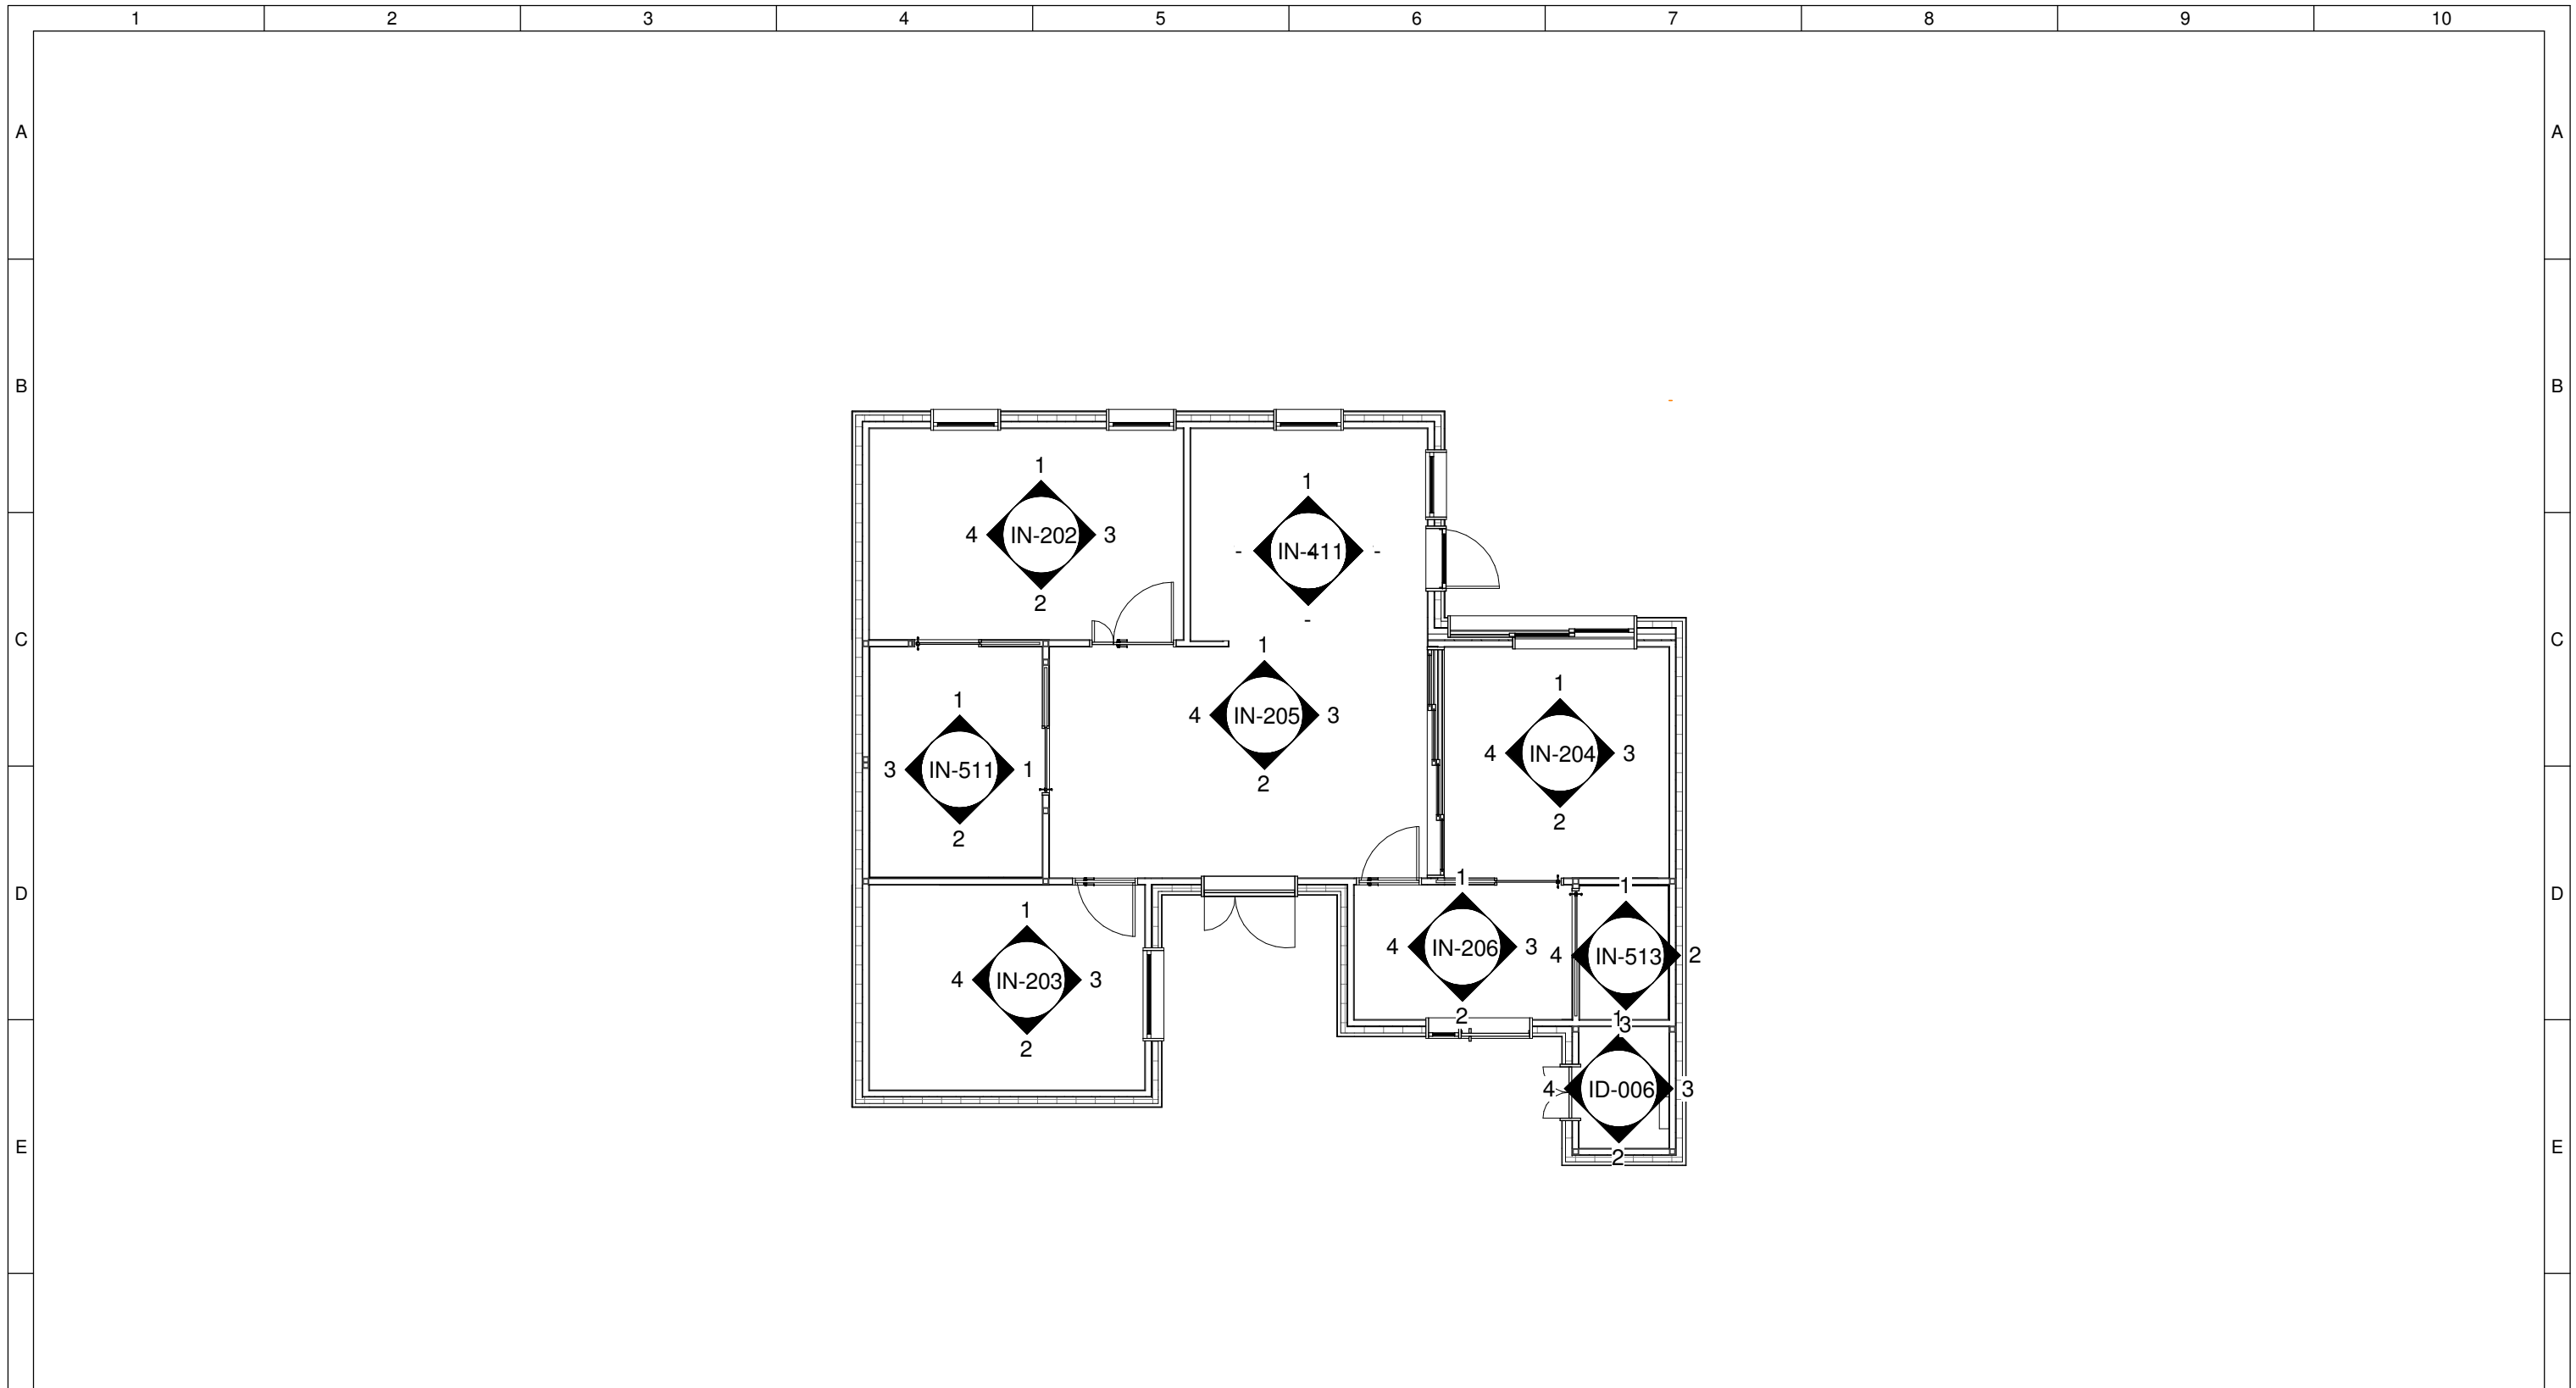


1

Interior Elevations Plan

 1 : 100



	Team: TEAM UOW Address: UNIVERSITY OF WOLLONGONG WOLLONGONG NSW, AUSTRALIA 2522	Client: Dubai Electricity and Water Authority 	AMENDMENTS				COPYRIGHT None; Project is Public		 NORTH	INTERIOR ELEVATIONS PLAN														
	Contact: sd-2018@uow.edu.au www.desertrosehouse.com.au		<table border="1"> <thead> <tr> <th>REV.</th> <th>DESCRIPTION</th> <th>DATE</th> <th>DRAWN</th> <th>CHECK</th> </tr> </thead> <tbody> <tr> <td>1</td> <td>Updated to As-Built</td> <td>14/09/1</td> <td>VP</td> <td>JR</td> </tr> </tbody> </table>	REV.	DESCRIPTION	DATE	DRAWN	CHECK			1	Updated to As-Built	14/09/1	VP	JR	<table border="1"> <tbody> <tr> <td>LOT</td> <td># M</td> </tr> <tr> <td>DRAWER</td> <td>J.ROTH</td> </tr> <tr> <td>CHECKED</td> <td>V.PHAM</td> </tr> <tr> <td>DATE</td> <td>20 February, 2018</td> </tr> <tr> <td>SCALE</td> <td>1 : 100 @ A3</td> </tr> </tbody> </table>	LOT	# M	DRAWER	J.ROTH	CHECKED	V.PHAM	DATE	20 February, 2018
REV.	DESCRIPTION	DATE	DRAWN	CHECK																				
1	Updated to As-Built	14/09/1	VP	JR																				
LOT	# M																							
DRAWER	J.ROTH																							
CHECKED	V.PHAM																							
DATE	20 February, 2018																							
SCALE	1 : 100 @ A3																							

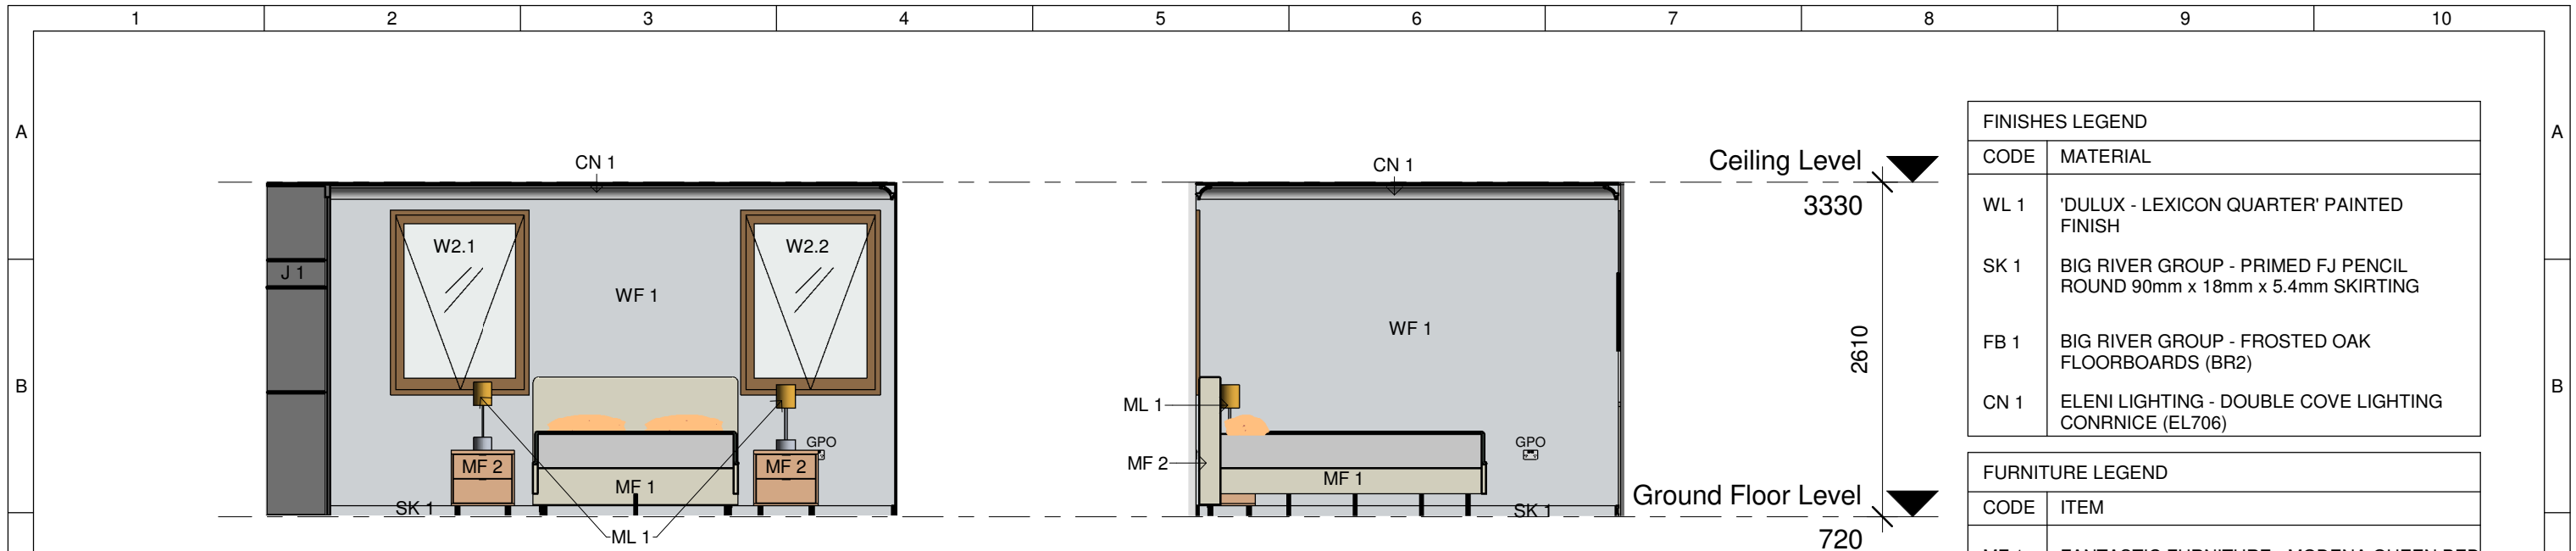

FINISHES LEGEND	
CODE	MATERIAL
WL 1	'DULUX - LEXICON QUARTER' PAINTED FINISH
SK 1	BIG RIVER GROUP - PRIMED FJ PENCIL ROUND 90mm x 18mm x 5.4mm SKIRTING
FB 1	BIG RIVER GROUP - FROSTED OAK FLOORBOARDS (BR2)
CN 1	ELENI LIGHTING - DOUBLE COVE LIGHTING CONRNICE (EL706)


FURNITURE LEGEND	
CODE	ITEM
MF 1	FANTASTIC FURNITURE - MODENA QUEEN BED
MF 2	APRIL & OAK - ATLANTA TWO DRAWER SIDE TABLE
MF 3	PICTURE FRAME

LIGHT FIXTURE LEGEND	
CODE	ITEM
ML 1	BEACON LIGHTING - ELK 1 LIGHT TABLE LAMP IN BRASS

JOINERY LEGEND	
CODE	ITEM
J 1	CUSTOM FABRICATED IN BUILT WARDROBE


1 Master Bedroom - North
1 : 50

3 Master Bedroom - East
1 : 50

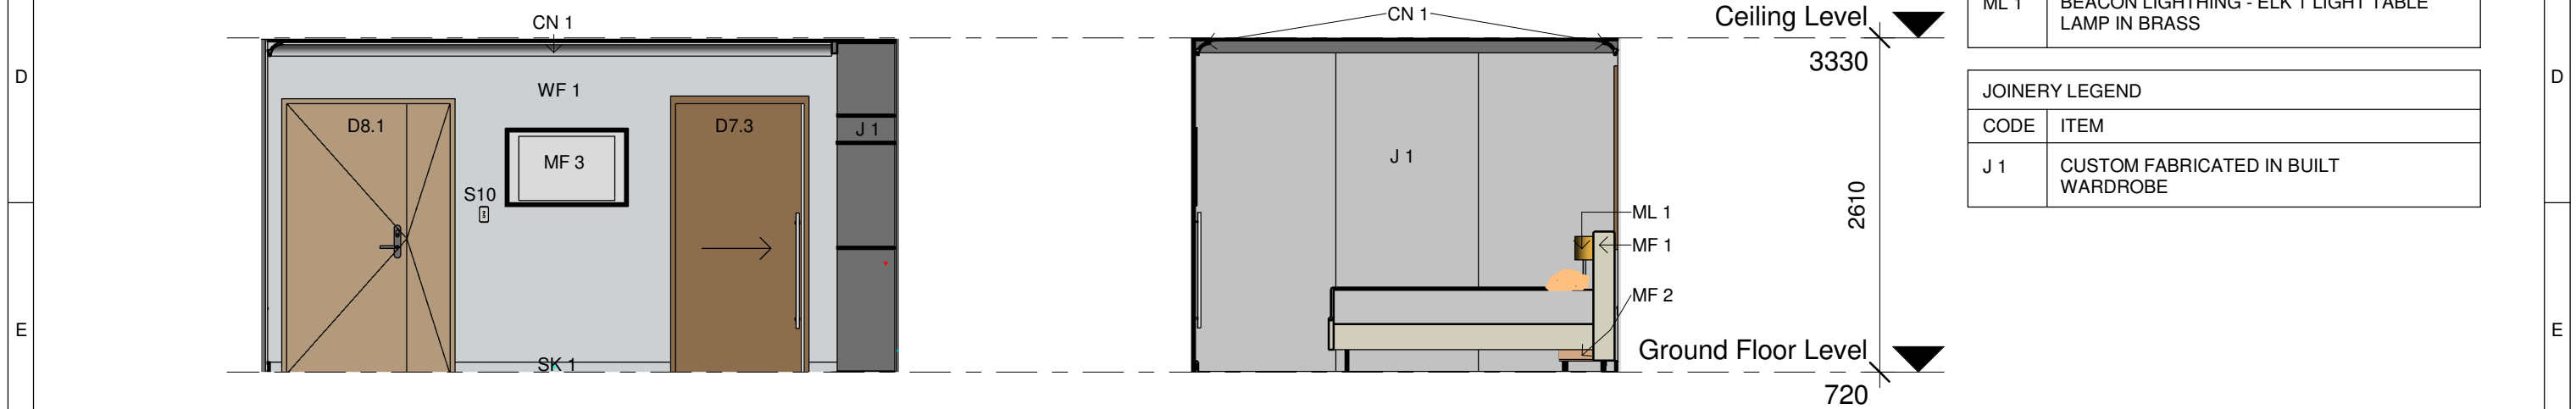


2 Master Bedroom - South
1 : 50


4 Master Bedroom - West
1 : 50

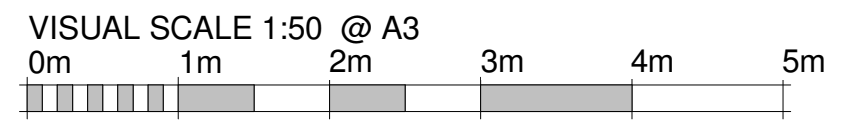


	Team: TEAM UOW Address: UNIVERSITY OF WOLLONGONG WOLLONGONG NSW, AUSTRALIA 2522 Contact: sd-2018@uow.edu.au www.desertrosehouse.com.au	Client: Dubai Electricity and Water Authority 	AMENDMENTS <table border="1"> <thead> <tr> <th>REV.</th> <th>DESCRIPTION</th> <th>DATE</th> <th>DRAWN</th> <th>CHECK</th> </tr> </thead> <tbody> <tr> <td>1</td> <td>Included Legend and updated detailing</td> <td>09/09/18</td> <td>CE</td> <td>VP</td> </tr> <tr> <td>2</td> <td>Updated to As-Built</td> <td>14/09/18</td> <td>VP</td> <td>JR</td> </tr> </tbody> </table>	REV.	DESCRIPTION	DATE	DRAWN	CHECK	1	Included Legend and updated detailing	09/09/18	CE	VP	2	Updated to As-Built	14/09/18	VP	JR	COPYRIGHT None; Project is Public LOT # M DRAWER C.EIO CHECKED V.PHAM DATE 20 February, 2018 SCALE 1 : 50 @ A3	MASTER BEDROOM ELEVATIONS IN-202 SHEET: 01 OF 01
	REV.	DESCRIPTION	DATE	DRAWN	CHECK															
1	Included Legend and updated detailing	09/09/18	CE	VP																
2	Updated to As-Built	14/09/18	VP	JR																

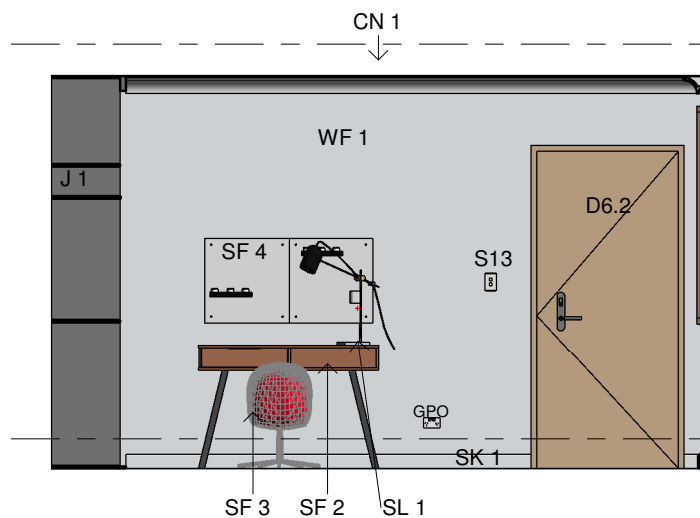


1 Guest Bedroom - North
1 : 50

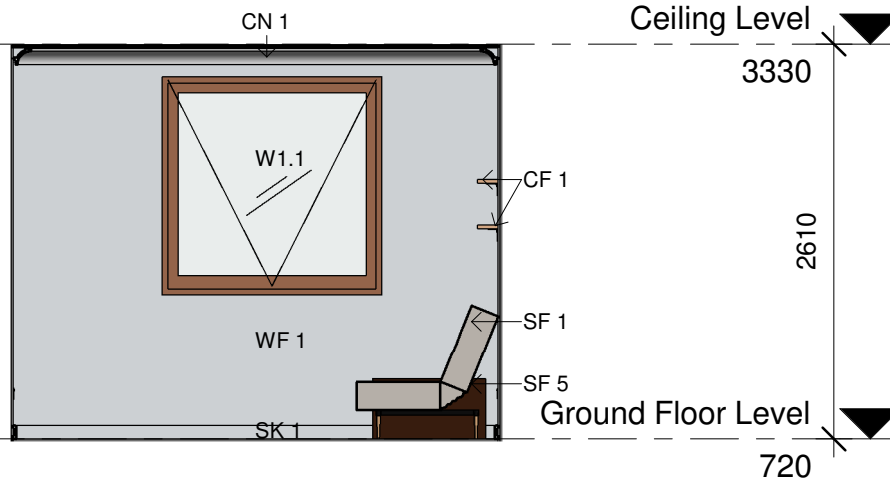

3 Guest Bedroom - East
1 : 50

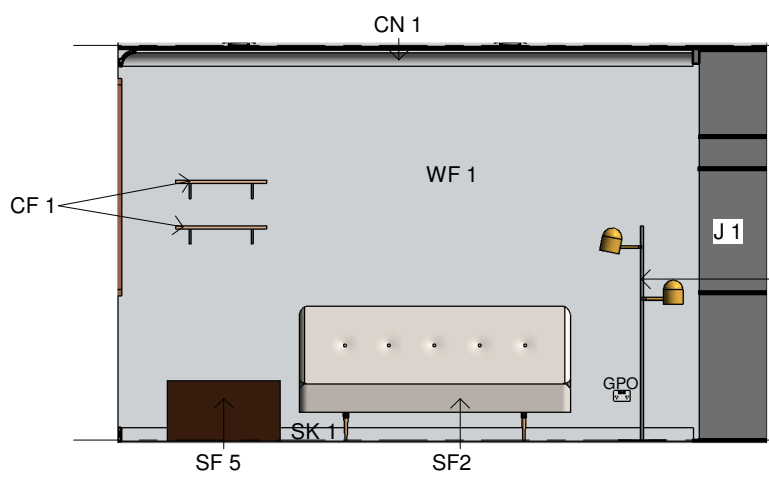

2 Guest Bedroom - South
1 : 50

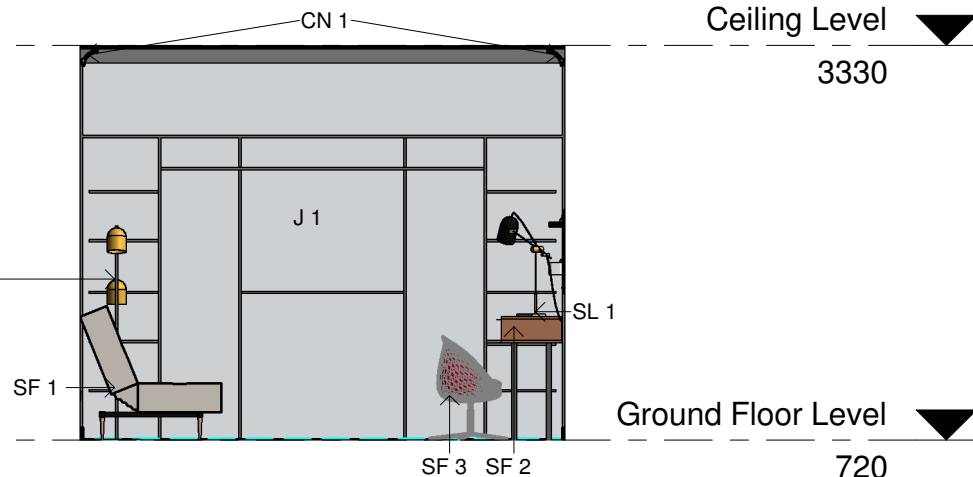


4 Guest Bedroom - West
1 : 50

FINISHES LEGEND	
CODE	MATERIAL
WF 1	'DULUX - LEXICON QUARTER' PAINTED FINISH
SK 1	BIG RIVER GROUP - PRIMED FJ PENCIL ROUND 90mm x 18mm x 5.4mm SKIRTING
FB 1	BIG RIVER GROUP - FROSTED OAK FLOORBOARDS (BR2)
CN 1	ELENI LIGHTING - DOUBLE COVE LIGHTING CONRNICE (EL706)

FURNITURE LEGEND	
CODE	ITEM
SF 1	BROSA - SLUMBER 3 SEATER SOFA BED IN 'STORM GREY'
SF 2	APRIL & OAK - ALTANTA EXECUTIVE DESK WITH METAL LEGS - NATURAL
SF 3	IKEA - SKRUVSTA SWIVEL CHAIR IN VISSLE GREY
SF 4	IKEA - SKÅDIS WHITE PEGBOARD
SF 5	OVELA - FOLDING OTTOMAN BED
CF 1	600 WIDE PLANK SHELVING

LIGHT FIXTURE LEGEND	
CODE	ITEM
SL 1	BEACON LIGHTING - CHESWICK TABLE LAMP IN BLACK
SL 2	BEACON LIGHTING - LEDLUX BLAKELY LED DIMMABLE 2 LIGHT FLOOR LAMP IN BLACK AND BRUSH BRASS

JOINERY LEGEND	
CODE	ITEM
J 1	CUSTOM FABRICATED IN BUILT WARDROBE

 

Team: TEAM UOW
Address: UNIVERSITY OF WOLLONGONG
 WOLLONGONG
 NSW, AUSTRALIA 2522
Contact: sd-2018@uow.edu.au
 www.desertrosehouse.com.au

Client: Dubai Electricity and Water Authority
SOLAR DECATHLON MIDDLE EAST DUBAI, UAE - 2018


AMENDMENTS					
REV.	DESCRIPTION	DATE	DRAWN	CHECK	
1	Included Legend and updated detailing	09/09/18	CE	VP	
2	Updated to As-Built	14/09/18	VP	JR	

COPYRIGHT	
None; Project is Public	
LOT	# M
DRAWER	C.EIO
CHECKED	V.PHAM
DATE	20 February, 2018
SCALE	1 : 50 @ A3


STUDY ROOM ELEVATIONS

SHEET: 01 OF 01

IN-203

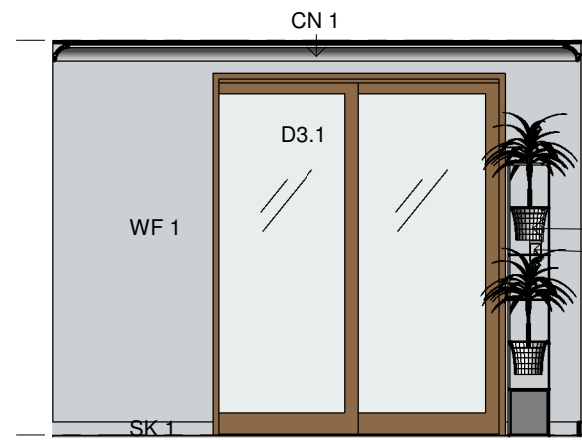


1 Living Room - North
1 : 50

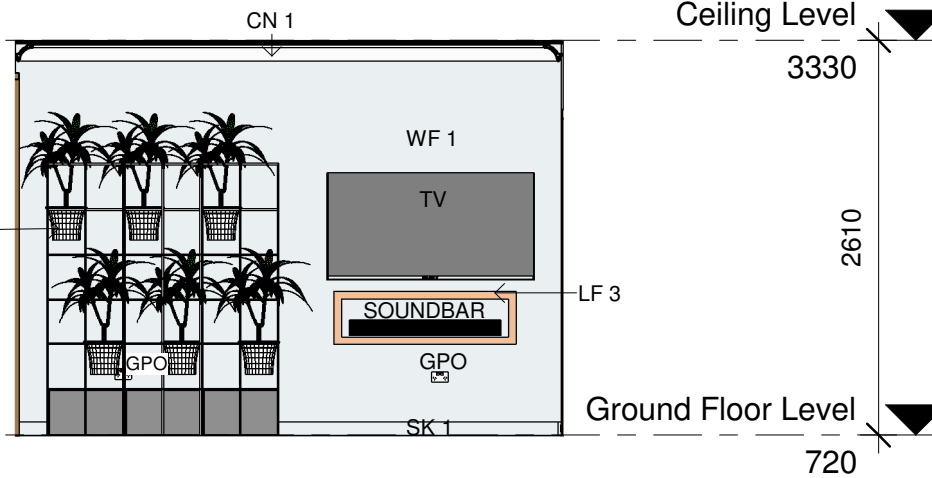


3 Living Room - East
1 : 50

FINISHES LEGEND	
CODE	MATERIAL
WF 1	'DULUX - LEXICON QUARTER' PAINTED FINISH
SK 1	BIG RIVER GROUP - PRIMED FJ PENCIL ROUND 90mm x 18mm x 5.4mm SKIRTING
FB 1	BIG RIVER GROUP - FROSTED OAK FLOORBOARDS (BR2)
CN 1	ELENI LIGHTING - DOUBLE COVE LIGHTING CONRNICE (EL706)


FURNITURE LEGEND	
CODE	ITEM
LF 1	TWO SEATER COUCH WITH WORTLEY FABRICS - 'GENOVA GOLD' UPHOLSTERED FINISH
LF 2	CUSTOM DESIGNED COFFEE TABLE REFER TO IN-303 (LRJ)
LF 3	CUSTOM MADE WALL BOX SHELVING
LF 4	CUSTOM MADE PLANTER SHELVES

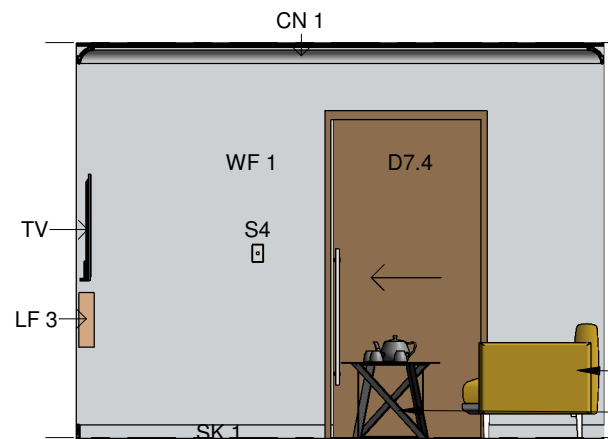


2 Living Room - South
1 : 50

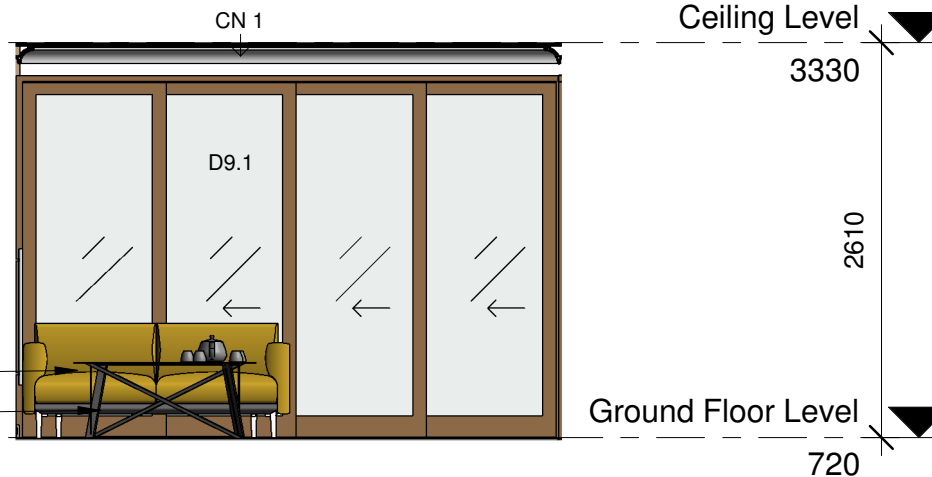

4 Living Room - West
1 : 50

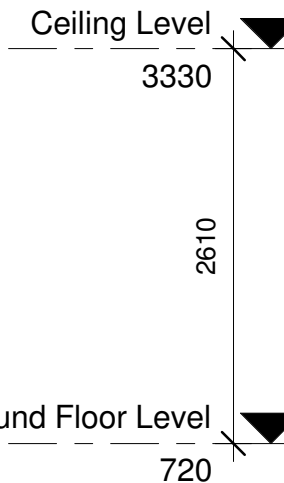


Team: TEAM UOW
Address: UNIVERSITY OF WOLLONGONG
 WOLLONGONG
 NSW, AUSTRALIA 2522
Contact: sd-2018@uow.edu.au
 www.desertrosehouse.com.au

Client: Dubai Electricity and Water Authority


AMENDMENTS					
REV.	DESCRIPTION	DATE	DRAWN	CHECK	
1	Included Legend and updated detailing	09/09/18	CE	VP	
2	Updated to As-Built	14/09/18	VP	JR	

COPYRIGHT
 None; Project is Public
 LOT # M
 DRAWER C.EIO
 CHECKED V.PHAM
 DATE 20 February, 2018
 SCALE 1 : 50 @ A3

LIVING ROOM ELEVATIONS
IN-204
 SHEET: 01 OF 01

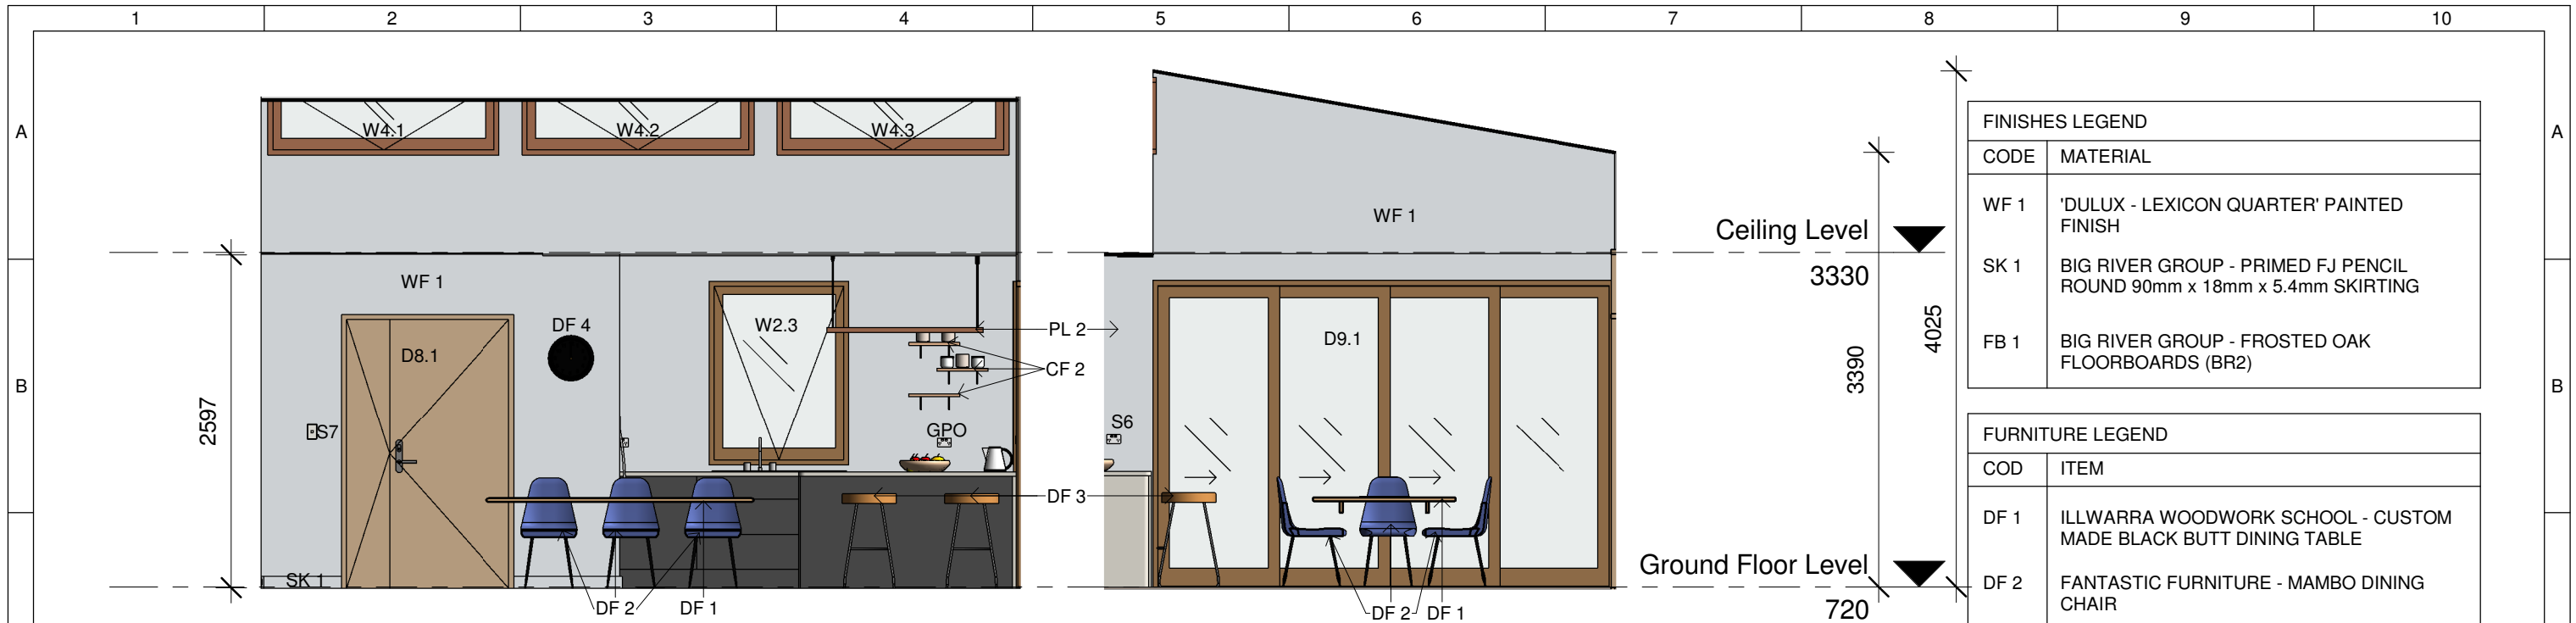


FINISHES LEGEND	
CODE	MATERIAL
WF 1	'DULUX - LEXICON QUARTER' PAINTED FINISH
SK 1	BIG RIVER GROUP - PRIMED FJ PENCIL ROUND 90mm x 18mm x 5.4mm SKIRTING
FB 1	BIG RIVER GROUP - FROSTED OAK FLOORBOARDS (BR2)

FURNITURE LEGEND	
COD	ITEM
DF 1	ILLWARRA WOODWORK SCHOOL - CUSTOM MADE BLACK BUTT DINING TABLE
DF 2	FANTASTIC FURNITURE - MAMBO DINING CHAIR
DF 3	OZDESIGN FURNITURE - TRACTOR 75CM STOOL - BLACK
DF 4	IKEA - SKÄRIG WALL CLOCK
CF 2	400 WIDE PLANK SHELIVING

LIGHT FIXTURE LEGEND	
COD	ITEM
PL 1	BEACON LIGHTING - HUSK 400mm BLACK PENDANT
PL 2	BEACON LIGHTING - LEDLUX STRIX LED 1600 LUMEN DIMMABLE PENDANT IN TEAK


1 Dining Room - North
1 : 50

3 Dining Room - East
1 : 50

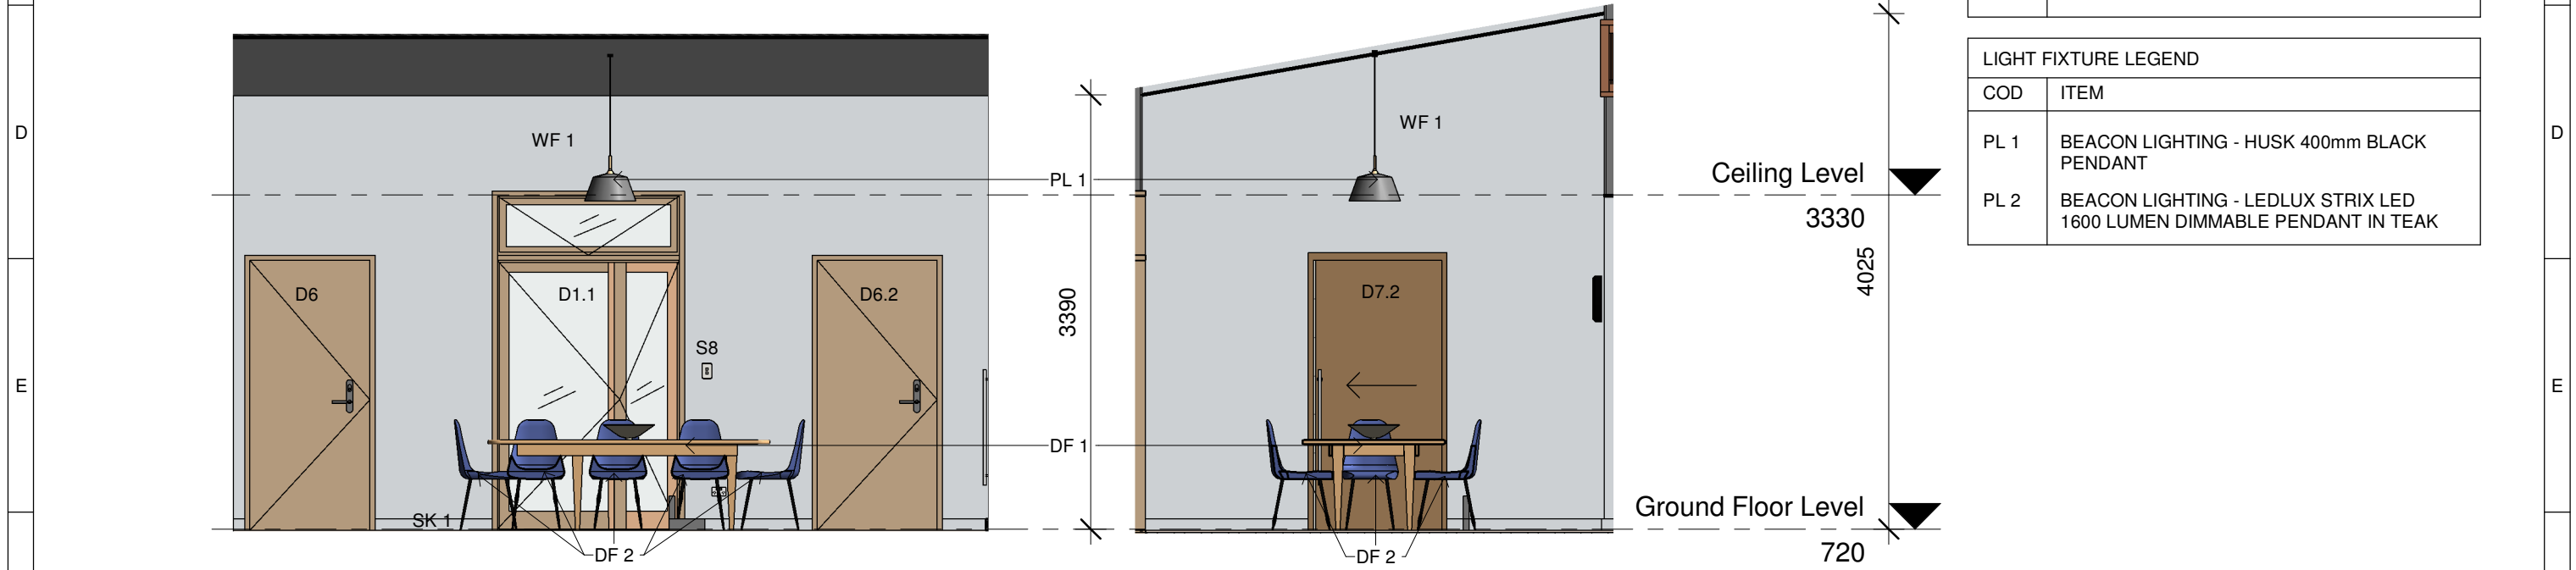


2 Dining Room - South
1 : 50


4 Dining Room - West
1 : 50

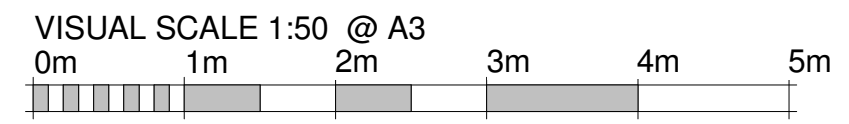


	Team: TEAM UOW Address: UNIVERSITY OF WOLLONGONG WOLLONGONG NSW, AUSTRALIA 2522 Contact: sd-2018@uow.edu.au www.desertrosehouse.com.au	Client: Dubai Electricity and Water Authority 	AMENDMENTS <table border="1"> <thead> <tr> <th>REV.</th> <th>DESCRIPTION</th> <th>DATE</th> <th>DRAWN</th> <th>CHECK</th> </tr> </thead> <tbody> <tr> <td>1</td> <td>Included Legend and updated detailing</td> <td>09/09/18</td> <td>CE</td> <td>VP</td> </tr> <tr> <td>2</td> <td>Updated to As-Built</td> <td>14/09/18</td> <td>VP</td> <td>JR</td> </tr> </tbody> </table>	REV.	DESCRIPTION	DATE	DRAWN	CHECK	1	Included Legend and updated detailing	09/09/18	CE	VP	2	Updated to As-Built	14/09/18	VP	JR	COPYRIGHT None; Project is Public LOT # M DRAWER C.EIO CHECKED V.PHAM DATE 20 February, 2018 SCALE 1 : 50 @ A3	DINING ROOM ELEVATIONS IN-205 SHEET: 01 OF 01
	REV.	DESCRIPTION	DATE	DRAWN	CHECK															
1	Included Legend and updated detailing	09/09/18	CE	VP																
2	Updated to As-Built	14/09/18	VP	JR																

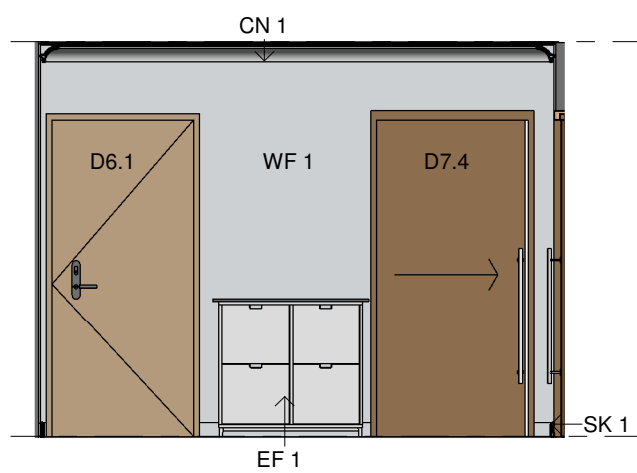


1 Entrance - North
1 : 50

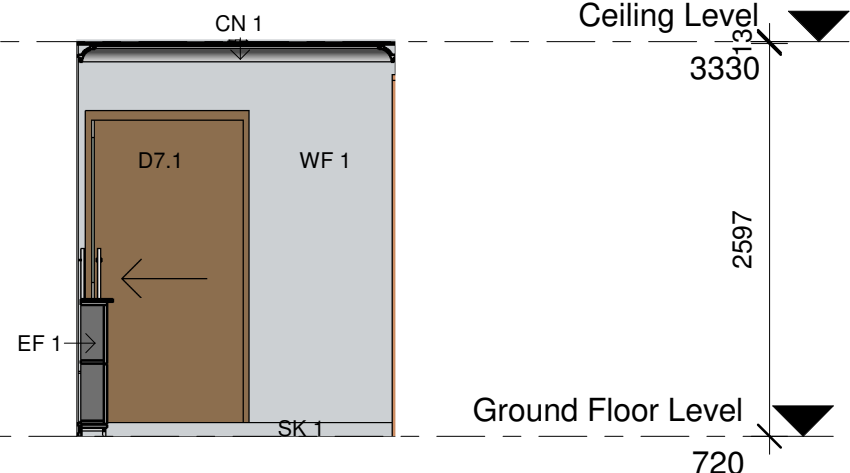

3 Entrance - East
1 : 50

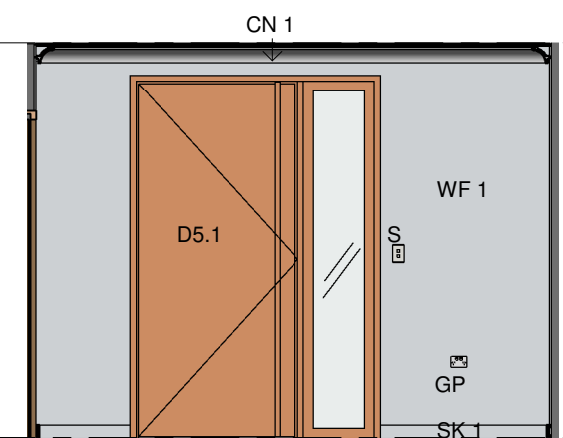


2 Entrance - South
1 : 50

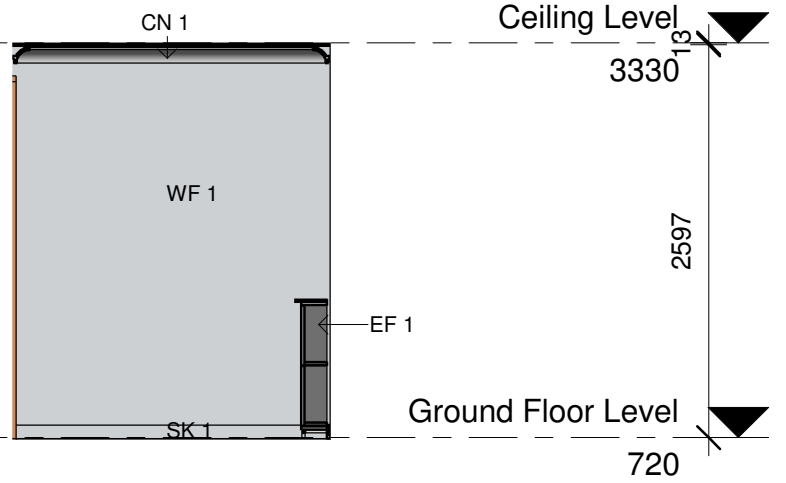

4 Entrance - West
1 : 50

FINISHES LEGEND	
CODE	MATERIAL
WF 1	'DULUX - LEXICON QUARTER' PAINTED FINISH
SK 1	BIG RIVER GROUP - PRIMED FJ PENCIL ROUND 90mm x 18mm x 5.4mm SKIRTING
FB 1	BIG RIVER GROUP - FROSTED OAK FLOORBOARDS (BR2)
CN 1	ELENI LIGHTING - DOUBLE COVE LIGHTING CONRNICE (EL706)

FURNITURE LEGEND	
CODE	ITEM
EF 1	IKEA - 'STÅLL' SHOE CABINET WITH 4 COMPARTMENTS, WHITE

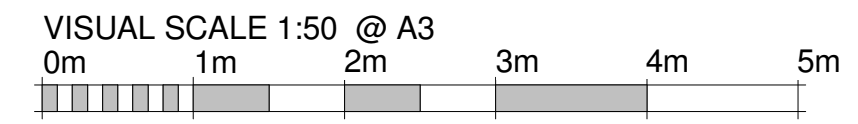

Team: TEAM UOW
Address: UNIVERSITY OF WOLLONGONG
 WOLLONGONG
 NSW, AUSTRALIA 2522
Contact: sd-2018@uow.edu.au
 www.desertrosehouse.com.au

Client: Dubai Electricity and Water Authority


AMENDMENTS				
REV.	DESCRIPTION	DATE	DRAWN	CHECK
1	Included Legend and updated detailing	09/09/18	CE	VP
2	Updated to As-Built	14/09/18	VP	JR

COPYRIGHT	
LOT	# M
None; Project is Public	
DRAWER	C.EIO
CHECKED	V.PHAM
DATE	20 February, 2018
SCALE	1 : 50 @ A3


ENTRANCE ELEVATIONS

SHEET: 01 OF 01

IN-206

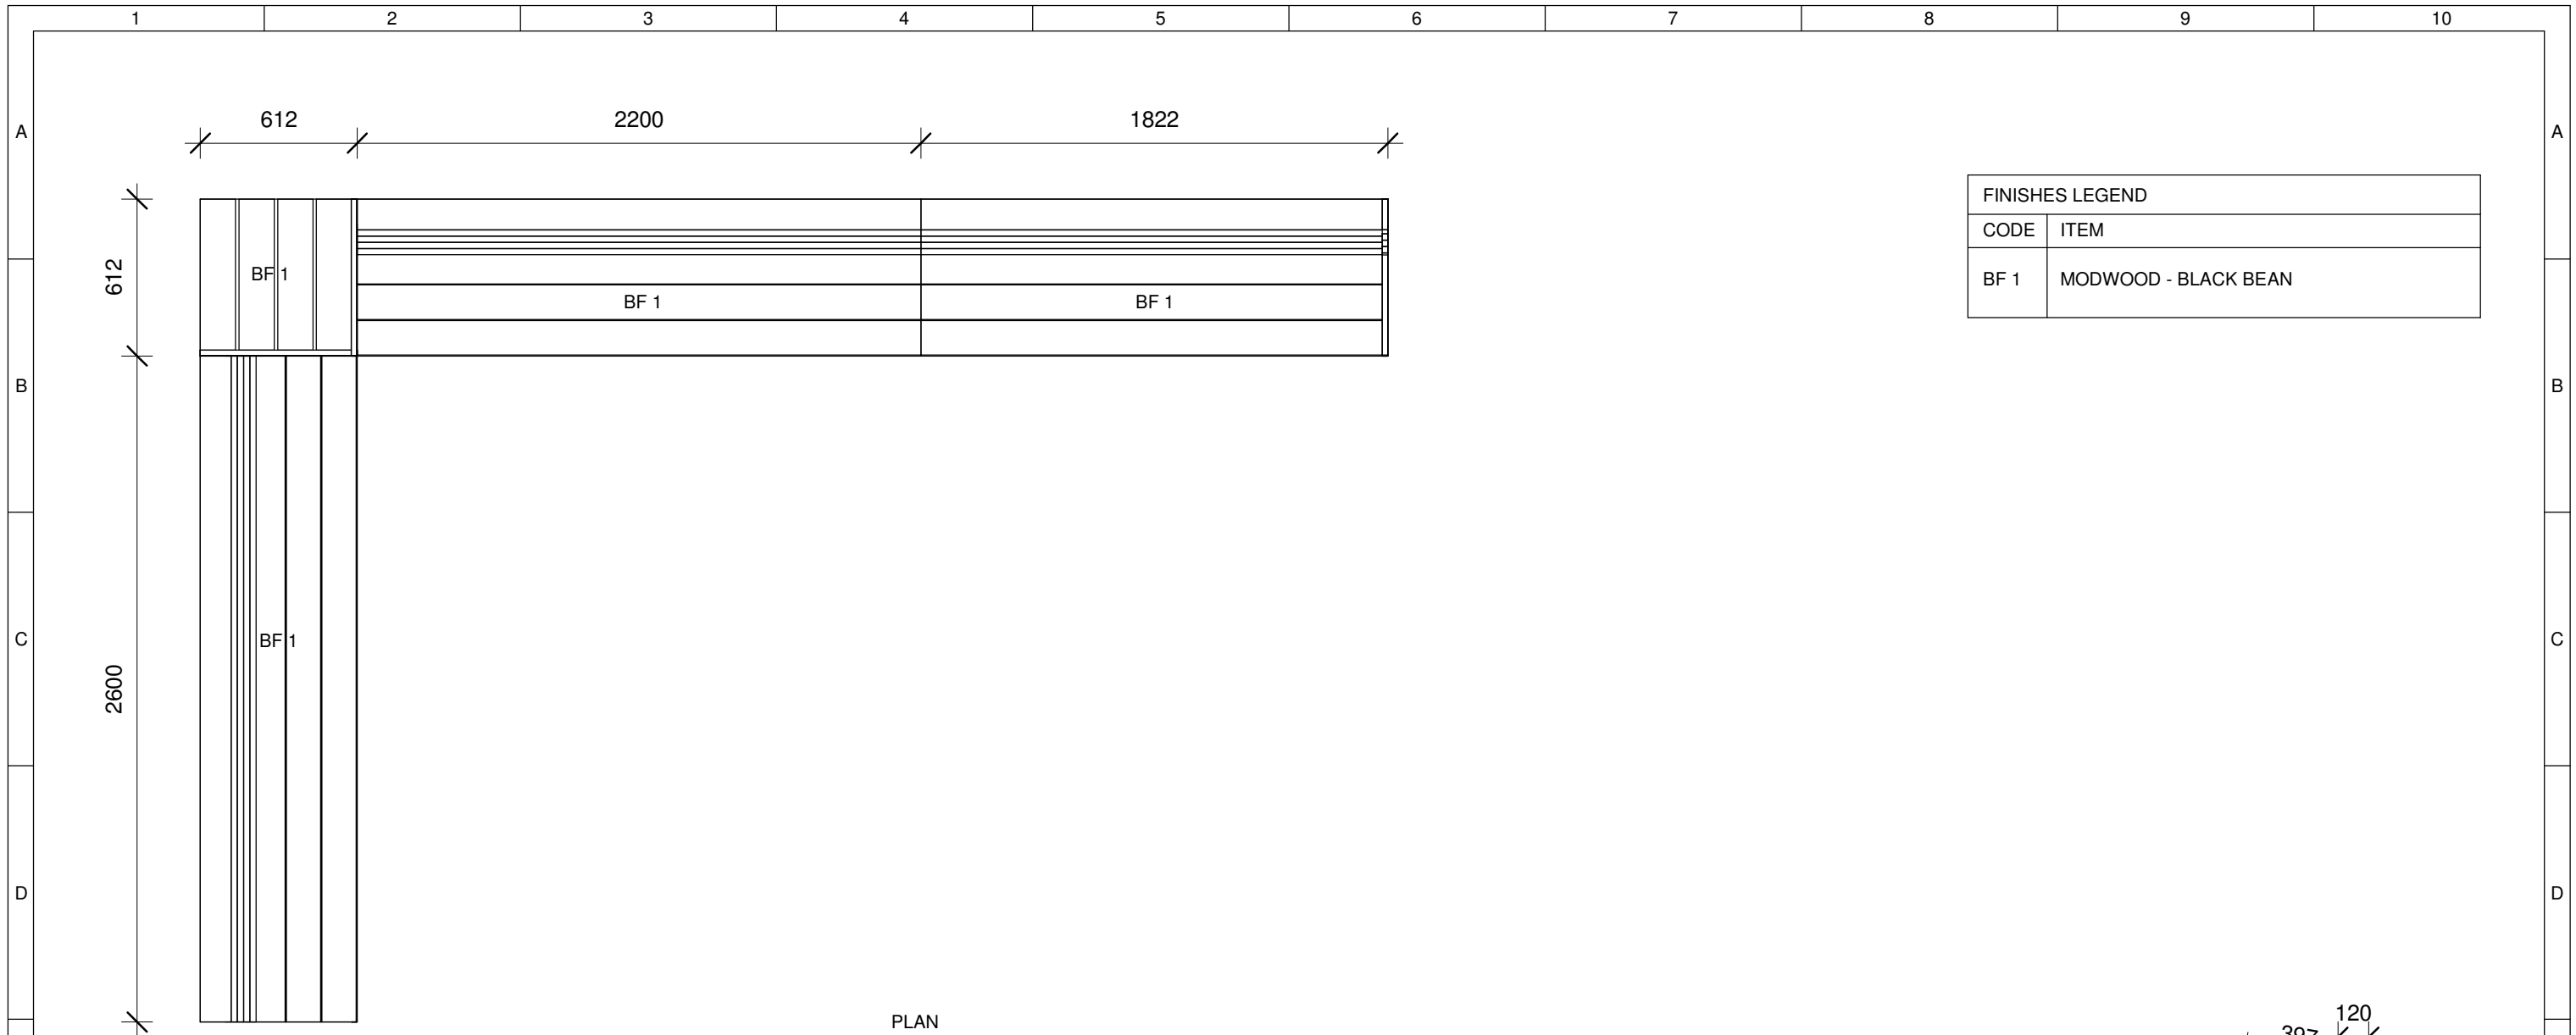

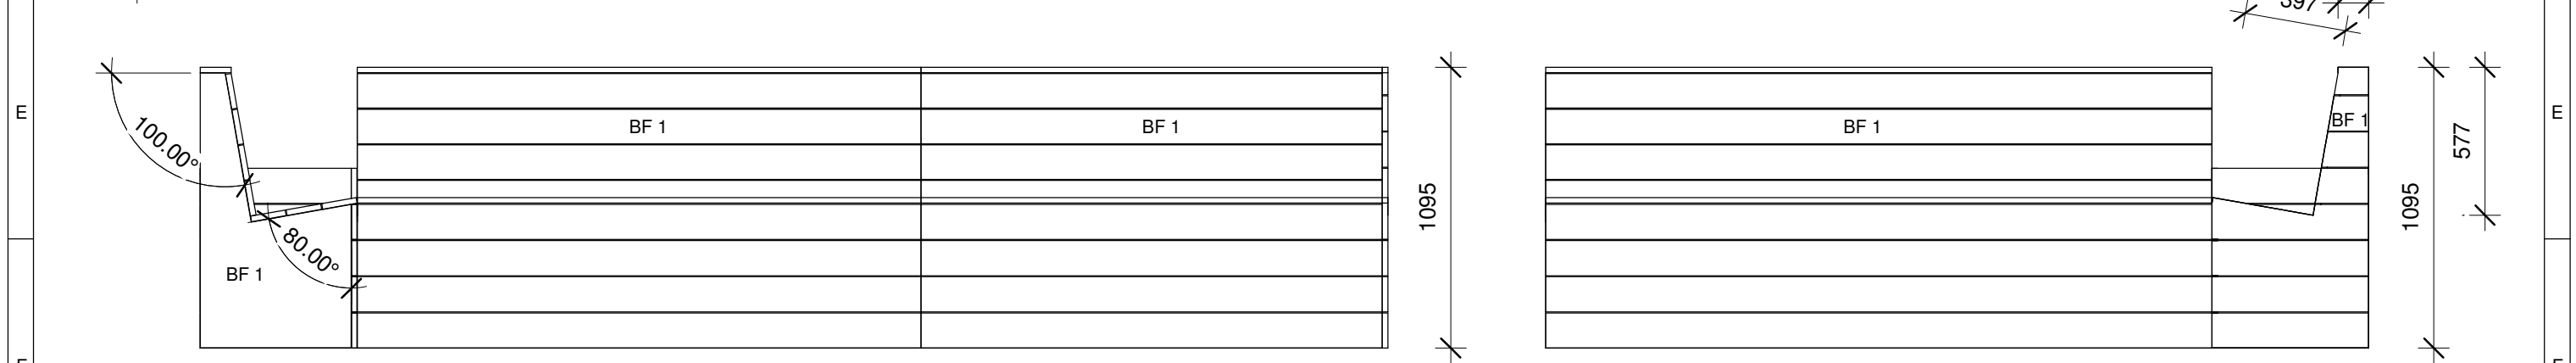

FINISHES LEGEND	
CODE	ITEM
BF 1	MODWOOD - BLACK BEAN




Back Deck Seating


1

1 : 25


 <p>Desert Rose Team UOW Australia - Dubai</p>	<p>Team: TEAM UOW</p> <p>Address: UNIVERSITY OF WOLLONGONG WOLLONGONG NSW, AUSTRALIA 2522</p> <p>Contact: sd-2018@uow.edu.au www.desertrosehouse.com.au</p>	<p>Client: Dubai Electricity and Water Authority</p> 	<p>AMENDMENTS</p> <table border="1"> <thead> <tr> <th>REV.</th> <th>DESCRIPTION</th> <th>DATE</th> <th>DRAWN</th> <th>CHECK</th> </tr> </thead> <tbody> <tr> <td>1</td> <td>Updated to As-Built</td> <td>14/09/1</td> <td>CE</td> <td>VP</td> </tr> </tbody> </table>	REV.	DESCRIPTION	DATE	DRAWN	CHECK	1	Updated to As-Built	14/09/1	CE	VP	<p>COPYRIGHT</p> <p>None; Project is Public</p> <table border="1"> <thead> <tr> <th>LOT</th> <th># M</th> </tr> </thead> <tbody> <tr> <td>DRAWER</td> <td>J.ROTH</td> </tr> <tr> <td>CHECKED</td> <td>V.PHAM</td> </tr> <tr> <td>DATE</td> <td>13 September, 2018</td> </tr> <tr> <td>SCALE</td> <td>1 : 25 @ A3</td> </tr> </tbody> </table>	LOT	# M	DRAWER	J.ROTH	CHECKED	V.PHAM	DATE	13 September, 2018	SCALE	1 : 25 @ A3	<p>FURNITURE DETAIL - BDJ</p> <p>SHEET: 01 OF 02</p> <p>IN-301</p>
	REV.	DESCRIPTION	DATE	DRAWN	CHECK																				
1	Updated to As-Built	14/09/1	CE	VP																					
LOT	# M																								
DRAWER	J.ROTH																								
CHECKED	V.PHAM																								
DATE	13 September, 2018																								
SCALE	1 : 25 @ A3																								

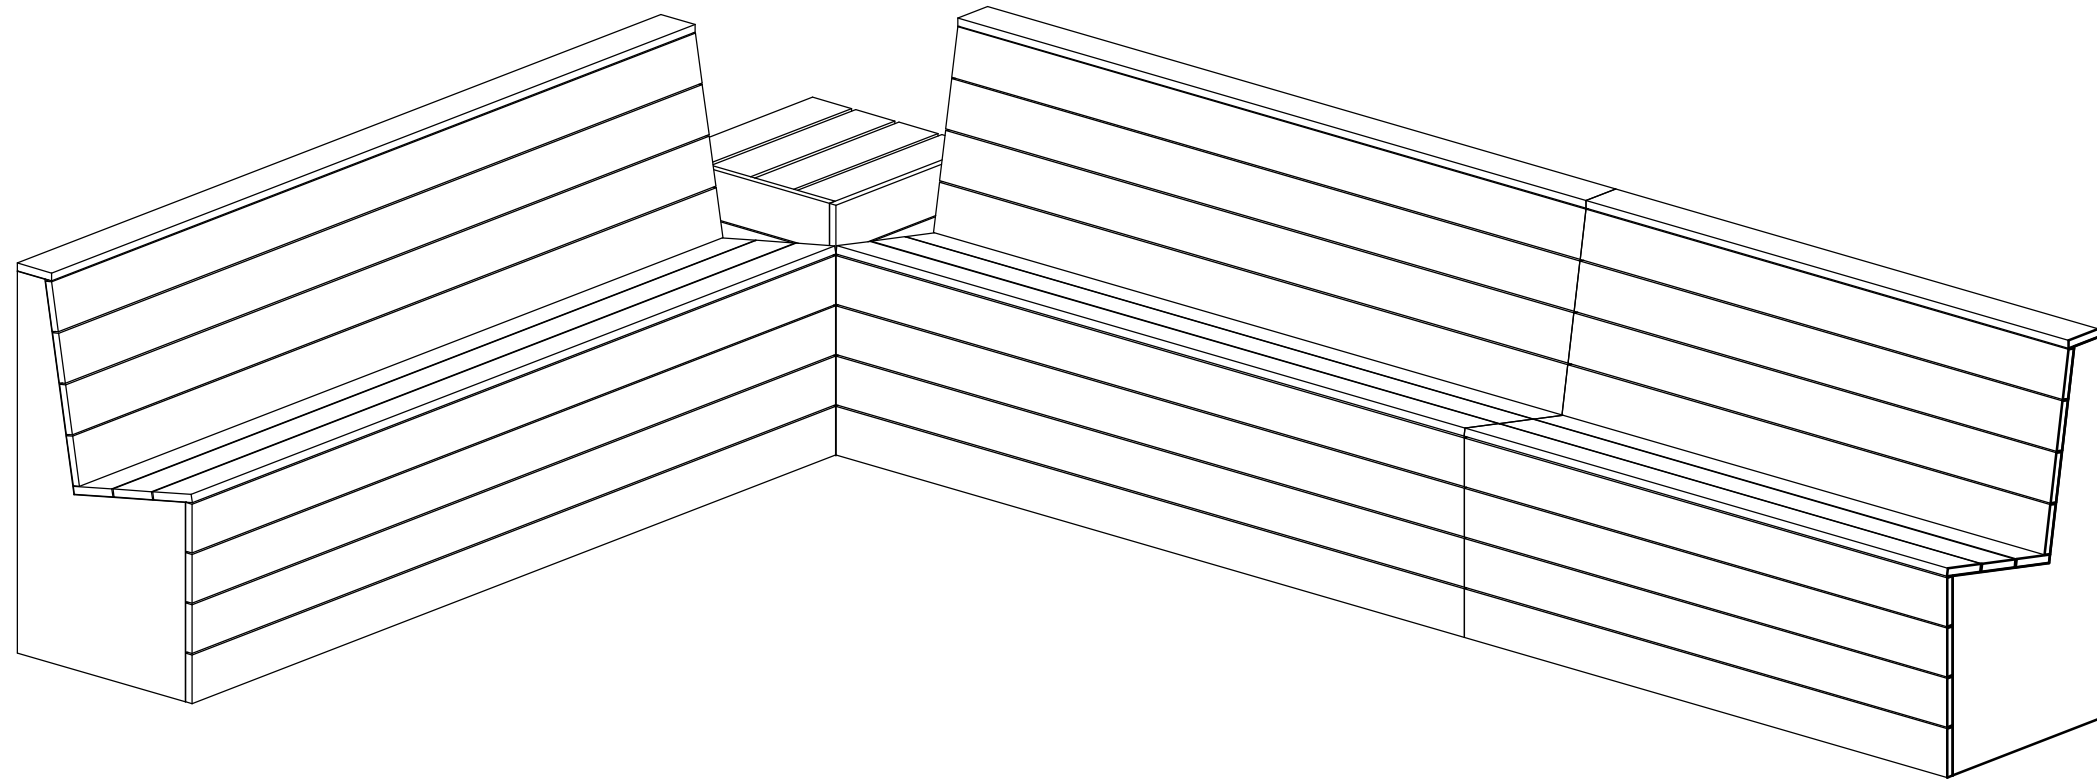


1 Back Deck Seating - 3D

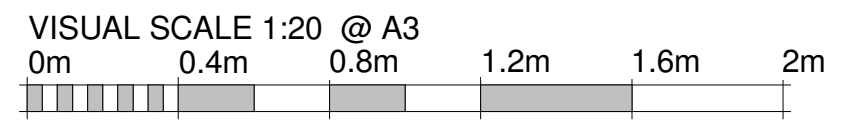

	Team: TEAM UOW Address: UNIVERSITY OF WOLLONGONG WOLLONGONG NSW, AUSTRALIA 2522	Client: Dubai Electricity and Water Authority 	AMENDMENTS				COPYRIGHT None; Project is Public		FURNITURE DETAIL - BDJ																													
	Contact: sd-2018@uow.edu.au www.desertrosehouse.com.au		<table border="1"> <thead> <tr> <th>REV.</th> <th>DESCRIPTION</th> <th>DATE</th> <th>DRAWN</th> <th>CHECK</th> </tr> </thead> <tbody> <tr> <td>1</td> <td>Updated to As-Built</td> <td>14/09/1</td> <td>CE</td> <td>VP</td> </tr> <tr> <td> </td> <td> </td> <td> </td> <td> </td> <td> </td> </tr> <tr> <td> </td> <td> </td> <td> </td> <td> </td> <td> </td> </tr> <tr> <td> </td> <td> </td> <td> </td> <td> </td> <td> </td> </tr> </tbody> </table>	REV.	DESCRIPTION	DATE	DRAWN	CHECK		1	Updated to As-Built	14/09/1	CE	VP																<table border="1"> <thead> <tr> <th>LOT</th> <th># M</th> </tr> </thead> <tbody> <tr> <td>DRAWER</td> <td>J.ROTH</td> </tr> <tr> <td>CHECKED</td> <td>V.PHAM</td> </tr> <tr> <td>DATE</td> <td>06 February, 2018</td> </tr> <tr> <td>SCALE</td> <td>@ A3</td> </tr> </tbody> </table>	LOT	# M	DRAWER	J.ROTH	CHECKED	V.PHAM	DATE	06 February, 2018
REV.	DESCRIPTION	DATE	DRAWN	CHECK																																		
1	Updated to As-Built	14/09/1	CE	VP																																		
LOT	# M																																					
DRAWER	J.ROTH																																					
CHECKED	V.PHAM																																					
DATE	06 February, 2018																																					
SCALE	@ A3																																					

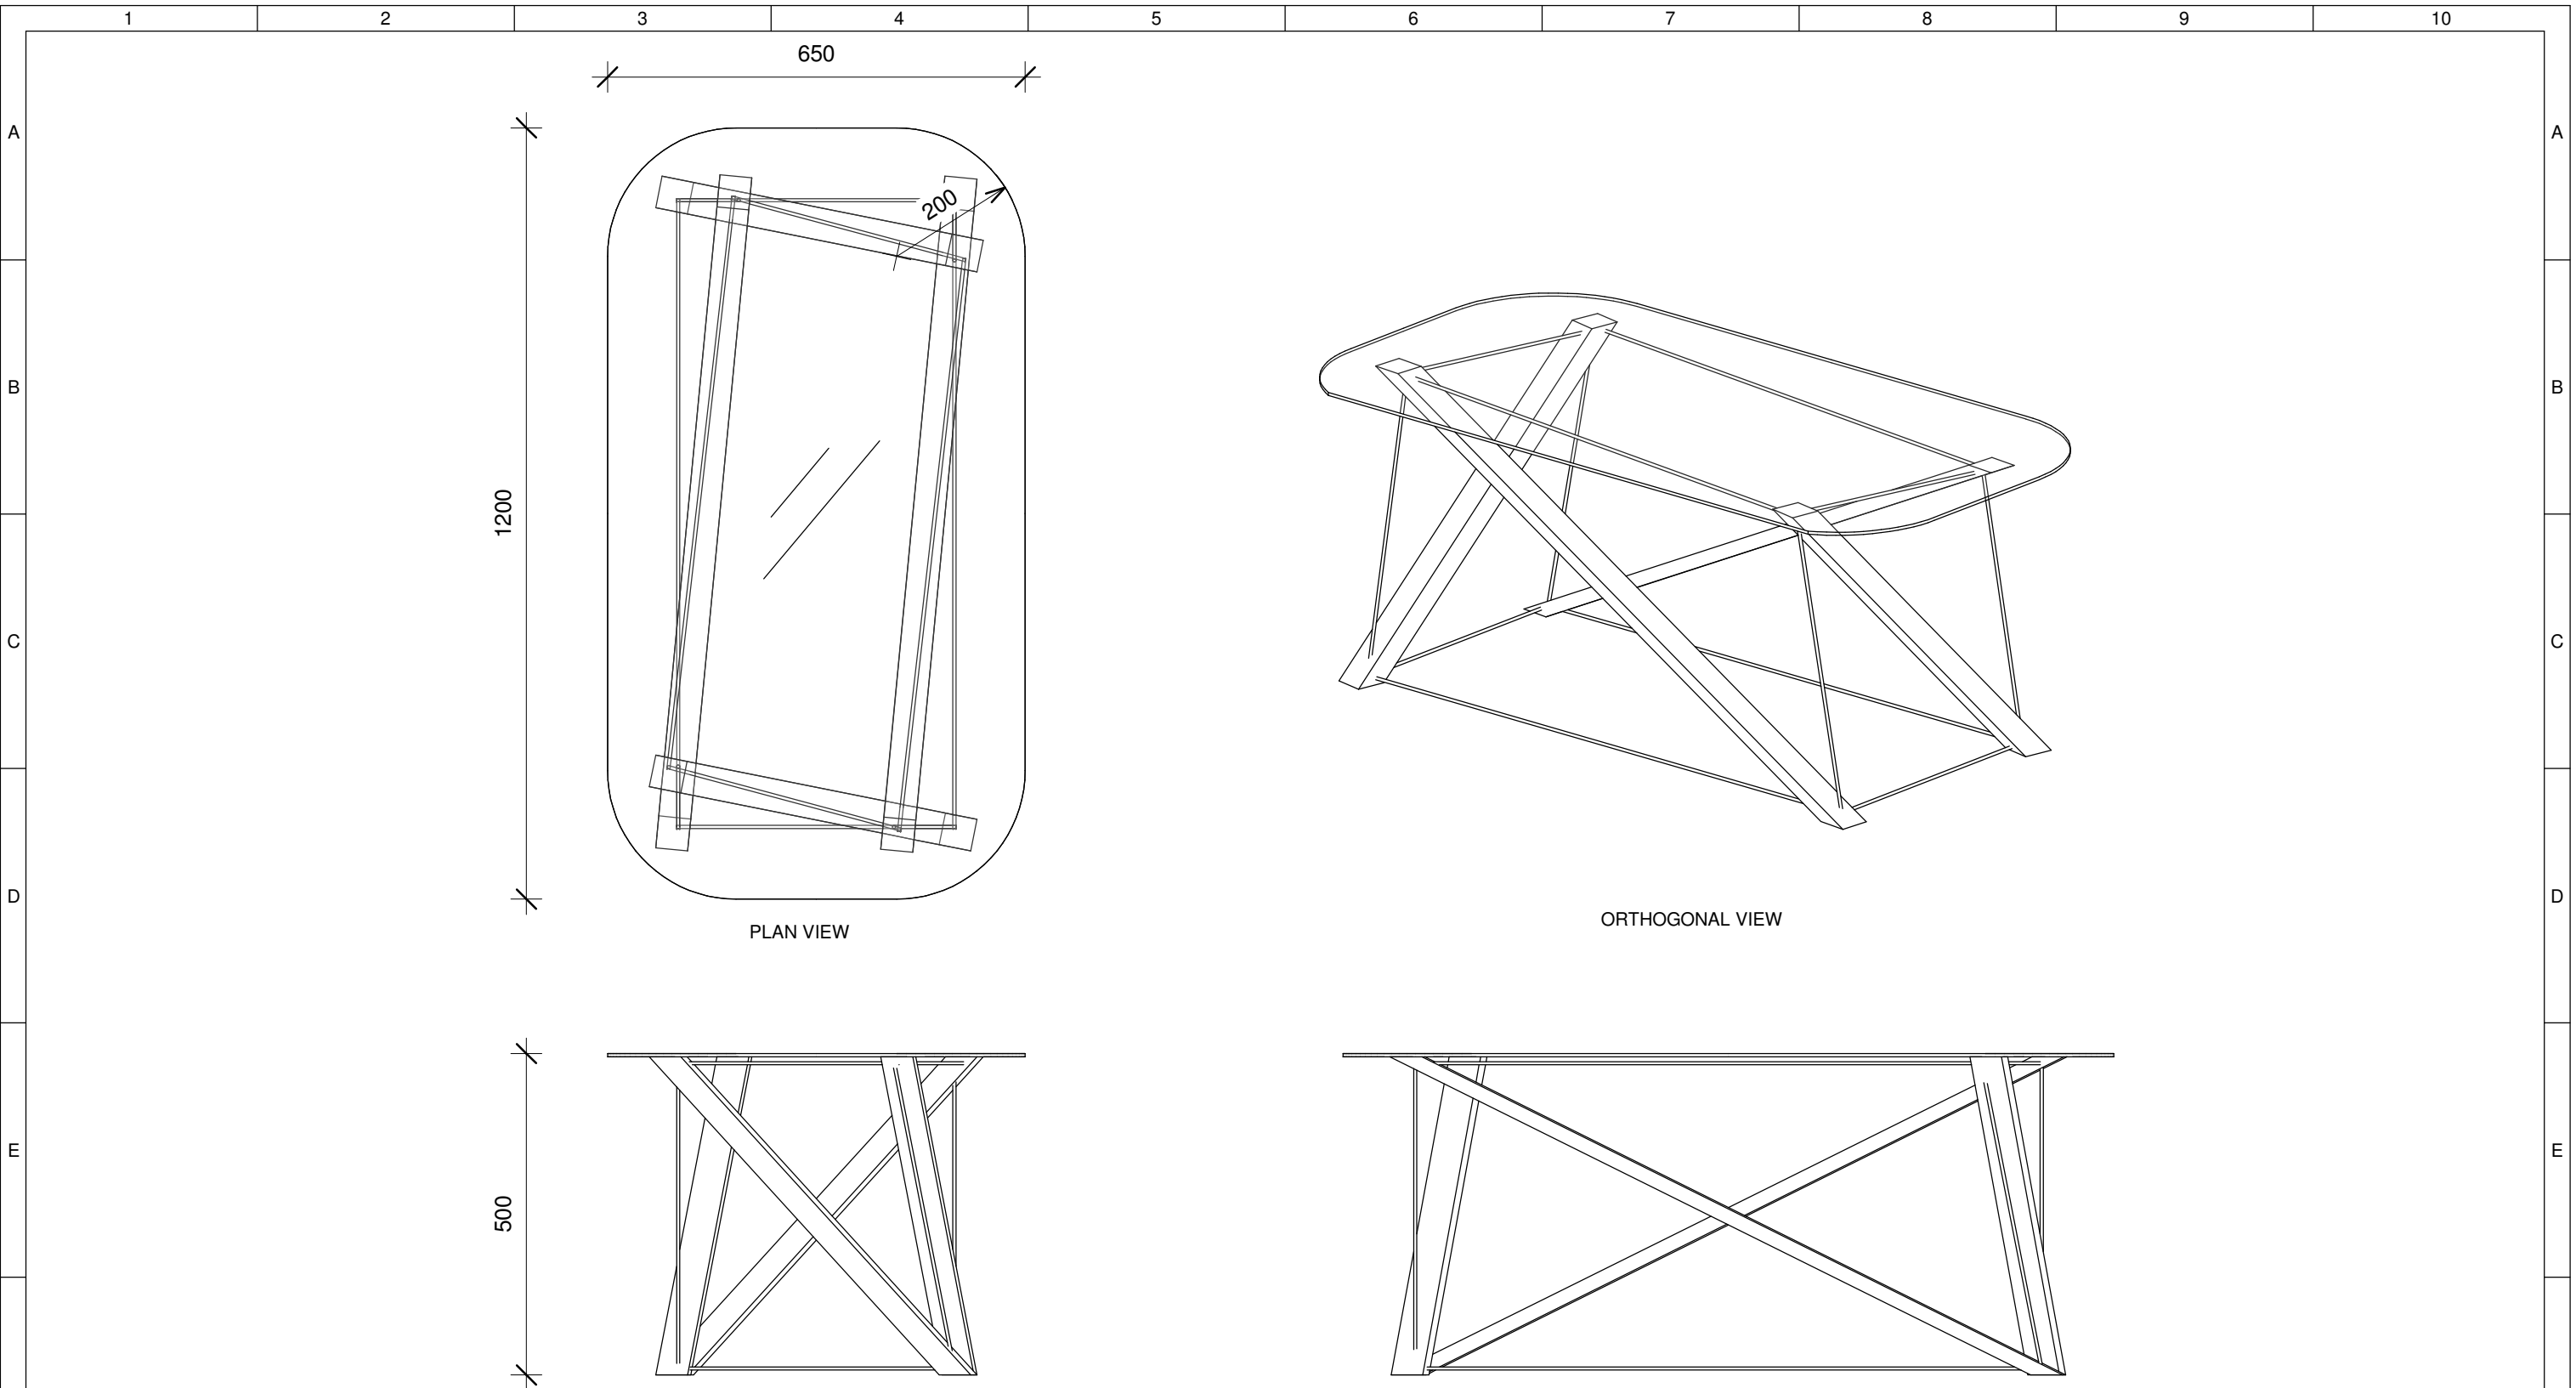

1 Coffee Table Concept
1 : 10

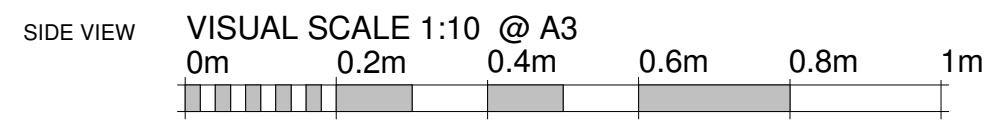

Team: TEAM UOW
Address: UNIVERSITY OF WOLLONGONG
 WOLLONGONG
 NSW, AUSTRALIA 2522
Contact: sd-2018@uow.edu.au
 www.desertrosehouse.com.au

Client:
 Dubai Electricity and Water Authority


AMENDMENTS				
REV.	DESCRIPTION	DATE	DRAWN	CHECK
1	Updated to As-Built	14/09/1	JR	VP

COPYRIGHT	
None; Project is Public	
LOT	# M
DRAWER	J.ROTH
CHECKED	V.PHAM
DATE	06 February, 2018
SCALE	1 : 10 @ A3

**FURNITURE
 DETAIL - LRJ**


SHEET:
 01 OF 01

IN-302

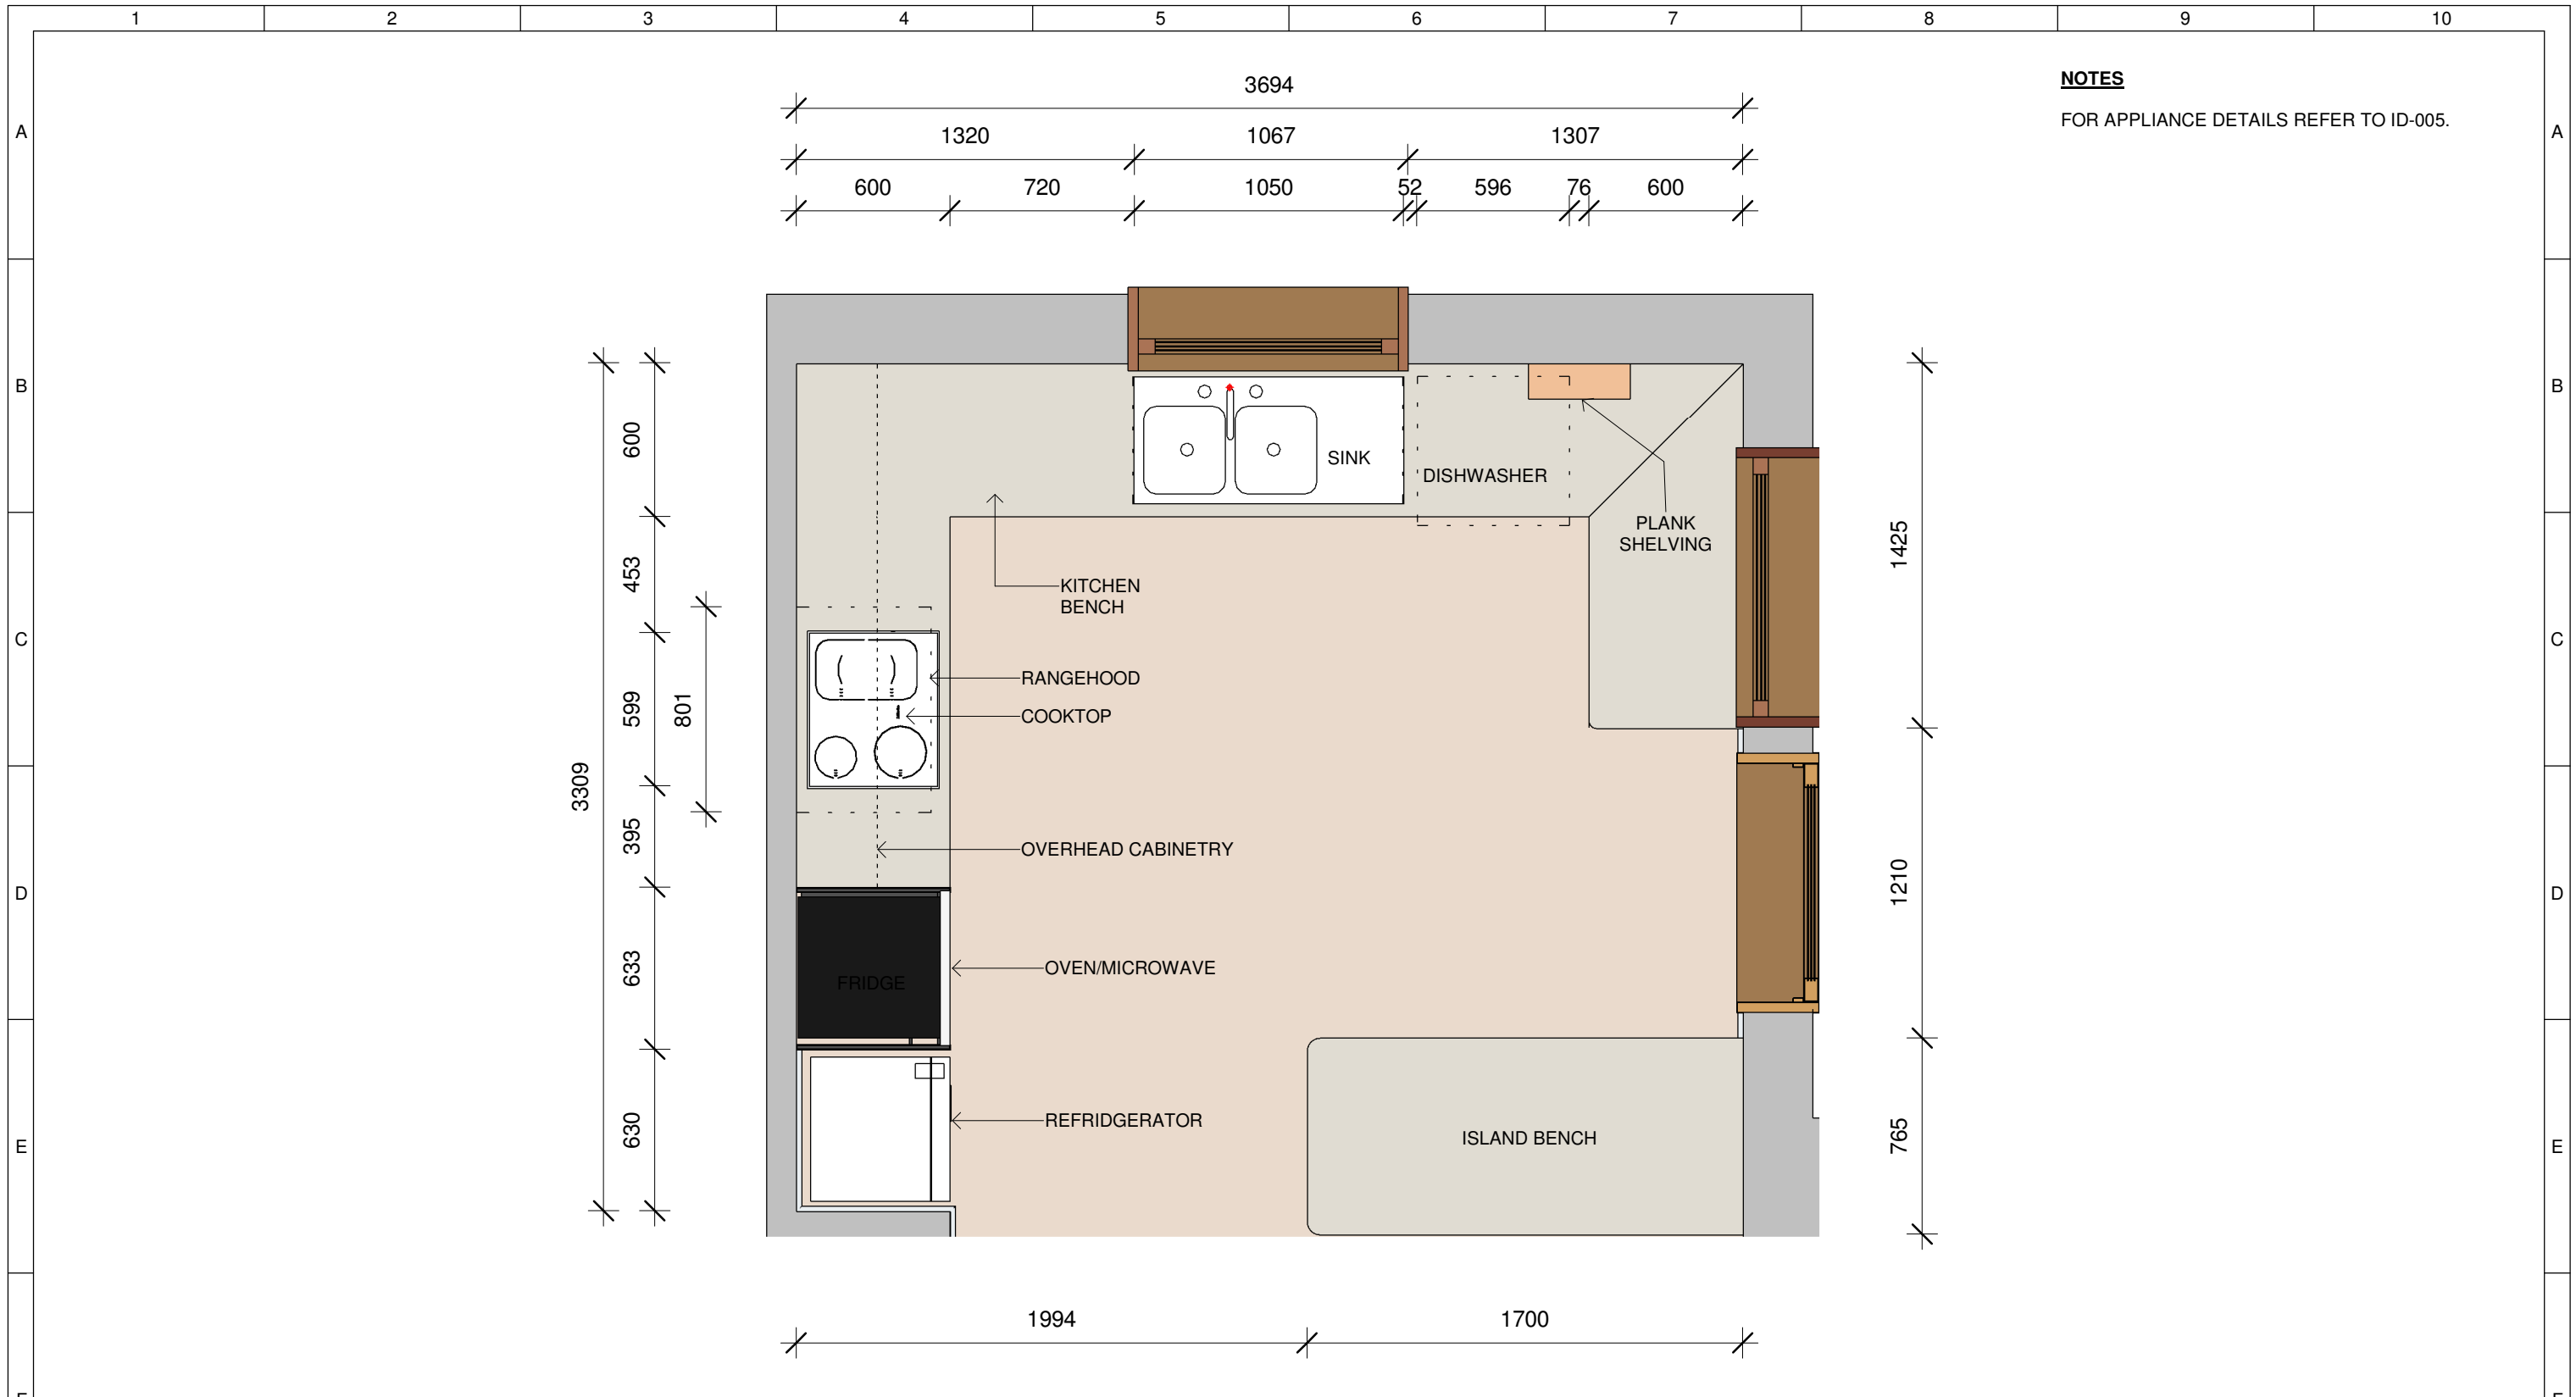


NOTES
FOR APPLIANCE DETAILS REFER TO ID-005.

1 Kitchen Plan
1 : 25

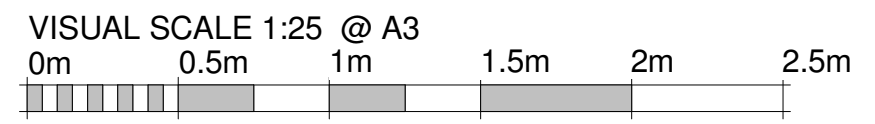


	Team: TEAM UOW Address: UNIVERSITY OF WOLLONGONG WOLLONGONG NSW, AUSTRALIA 2522	Client: Dubai Electricity and Water Authority 	AMENDMENTS			COPYRIGHT None; Project is Public		KITCHEN PLAN																					
	Contact: sd-2018@uow.edu.au www.desertrosehouse.com.au		<table border="1"> <thead> <tr> <th>REV.</th> <th>DESCRIPTION</th> <th>DATE</th> <th>DRAWN</th> <th>CHECK</th> </tr> </thead> <tbody> <tr> <td>1</td> <td>Updated Plans, Detailing and Template Adjustments</td> <td>01/02/18</td> <td>JR</td> <td>VP</td> </tr> <tr> <td>2</td> <td>Updated to As-Built</td> <td>14/09/18</td> <td>VP</td> <td>JR</td> </tr> </tbody> </table>	REV.	DESCRIPTION	DATE	DRAWN		CHECK	1	Updated Plans, Detailing and Template Adjustments	01/02/18	JR	VP	2	Updated to As-Built	14/09/18	VP	JR	<table border="1"> <tbody> <tr> <td>LOT</td> <td># M</td> </tr> <tr> <td>DRAWER</td> <td>J.ROTH</td> </tr> <tr> <td>CHECKED</td> <td>V.PHAM</td> </tr> <tr> <td>DATE</td> <td>20 February, 2018</td> </tr> <tr> <td>SCALE</td> <td>1 : 25 @ A3</td> </tr> </tbody> </table>	LOT	# M	DRAWER	J.ROTH	CHECKED	V.PHAM	DATE	20 February, 2018	SCALE
REV.	DESCRIPTION	DATE	DRAWN	CHECK																									
1	Updated Plans, Detailing and Template Adjustments	01/02/18	JR	VP																									
2	Updated to As-Built	14/09/18	VP	JR																									
LOT	# M																												
DRAWER	J.ROTH																												
CHECKED	V.PHAM																												
DATE	20 February, 2018																												
SCALE	1 : 25 @ A3																												

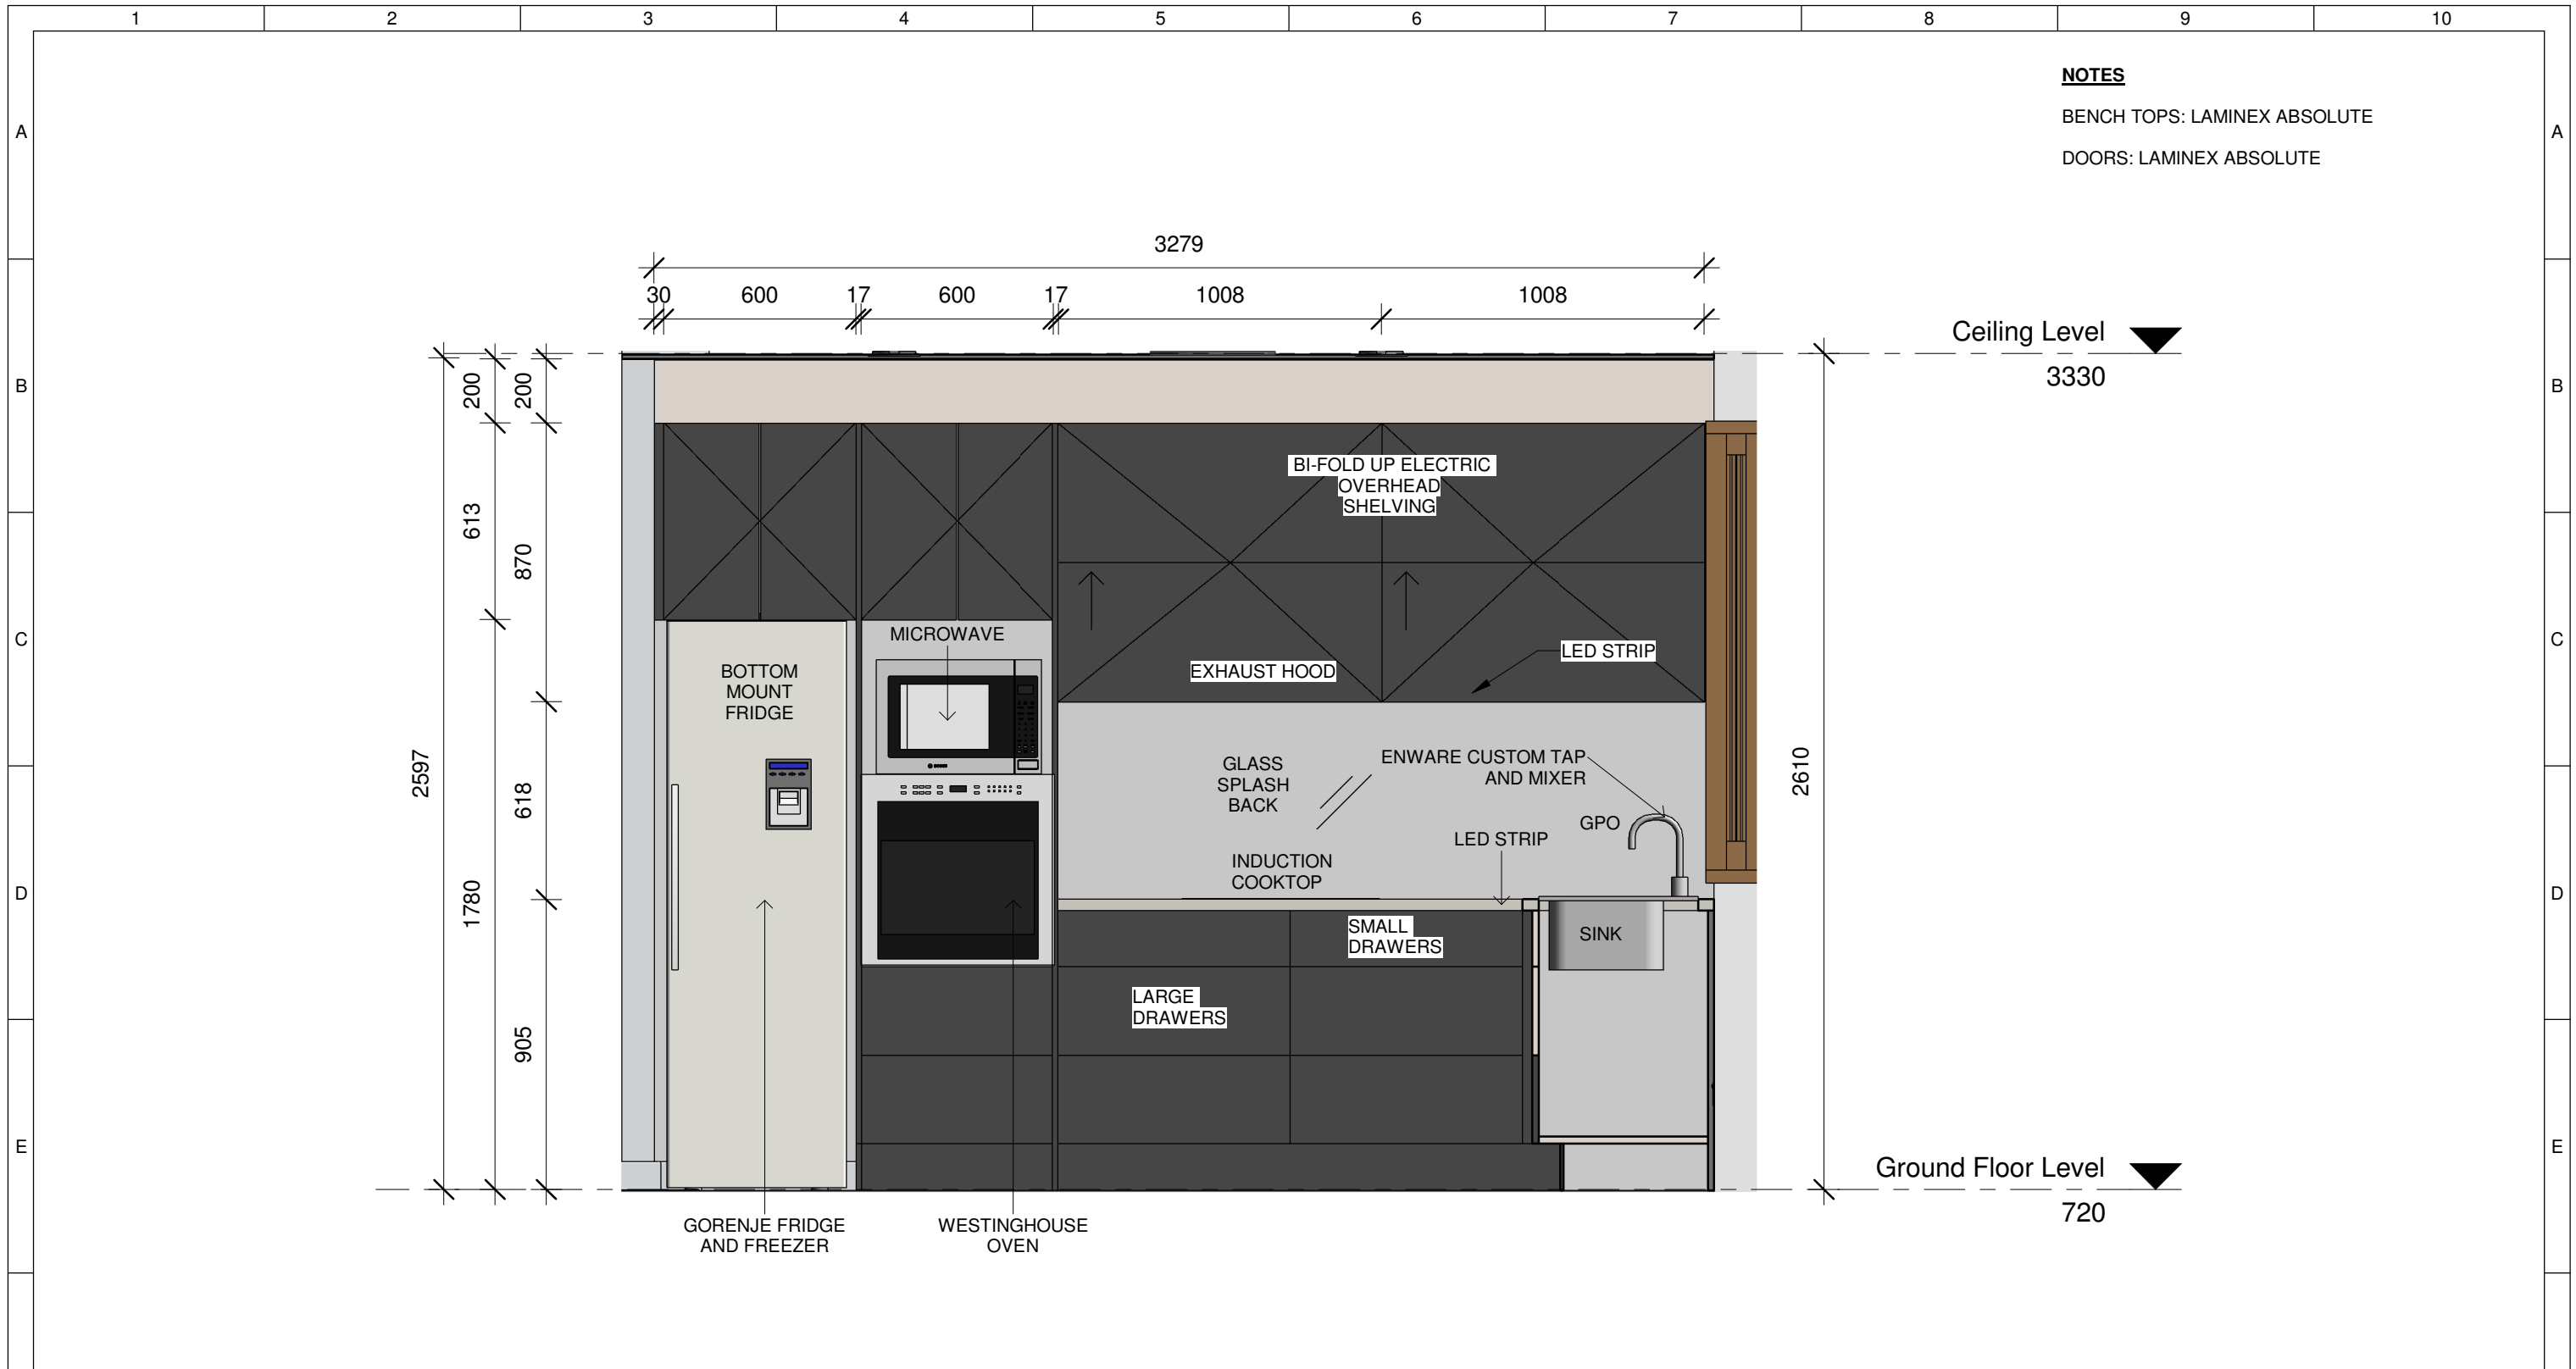


NOTES
 BENCH TOPS: LAMINEX ABSOLUTE
 DOORS: LAMINEX ABSOLUTE

1 Kitchen Elevation - East
 1 : 20

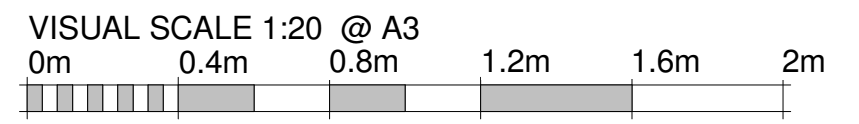


	Team: TEAM UOW Address: UNIVERSITY OF WOLLONGONG WOLLONGONG NSW, AUSTRALIA 2522 Contact: sd-2018@uow.edu.au www.desertrosehouse.com.au	Client: Dubai Electricity and Water Authority 	AMENDMENTS <table border="1"> <thead> <tr> <th>REV.</th> <th>DESCRIPTION</th> <th>DATE</th> <th>DRAWN</th> <th>CHECK</th> </tr> </thead> <tbody> <tr> <td>1</td> <td>Updated to As-Built</td> <td>14/09/18</td> <td>C</td> <td>VP</td> </tr> </tbody> </table>	REV.	DESCRIPTION	DATE	DRAWN	CHECK	1	Updated to As-Built	14/09/18	C	VP	COPYRIGHT None; Project is Public LOT # M DRAWER C.EIO CHECKED V.PHAM DATE 20 February, 2018 SCALE 1 : 20 @ A3	KITCHEN ELEVATION - WEST IN-411 SHEET: 01 OF 01
	REV.	DESCRIPTION	DATE	DRAWN	CHECK										
1	Updated to As-Built	14/09/18	C	VP											
<p>1 2 3 4 5 6 7 8 9 10</p>															

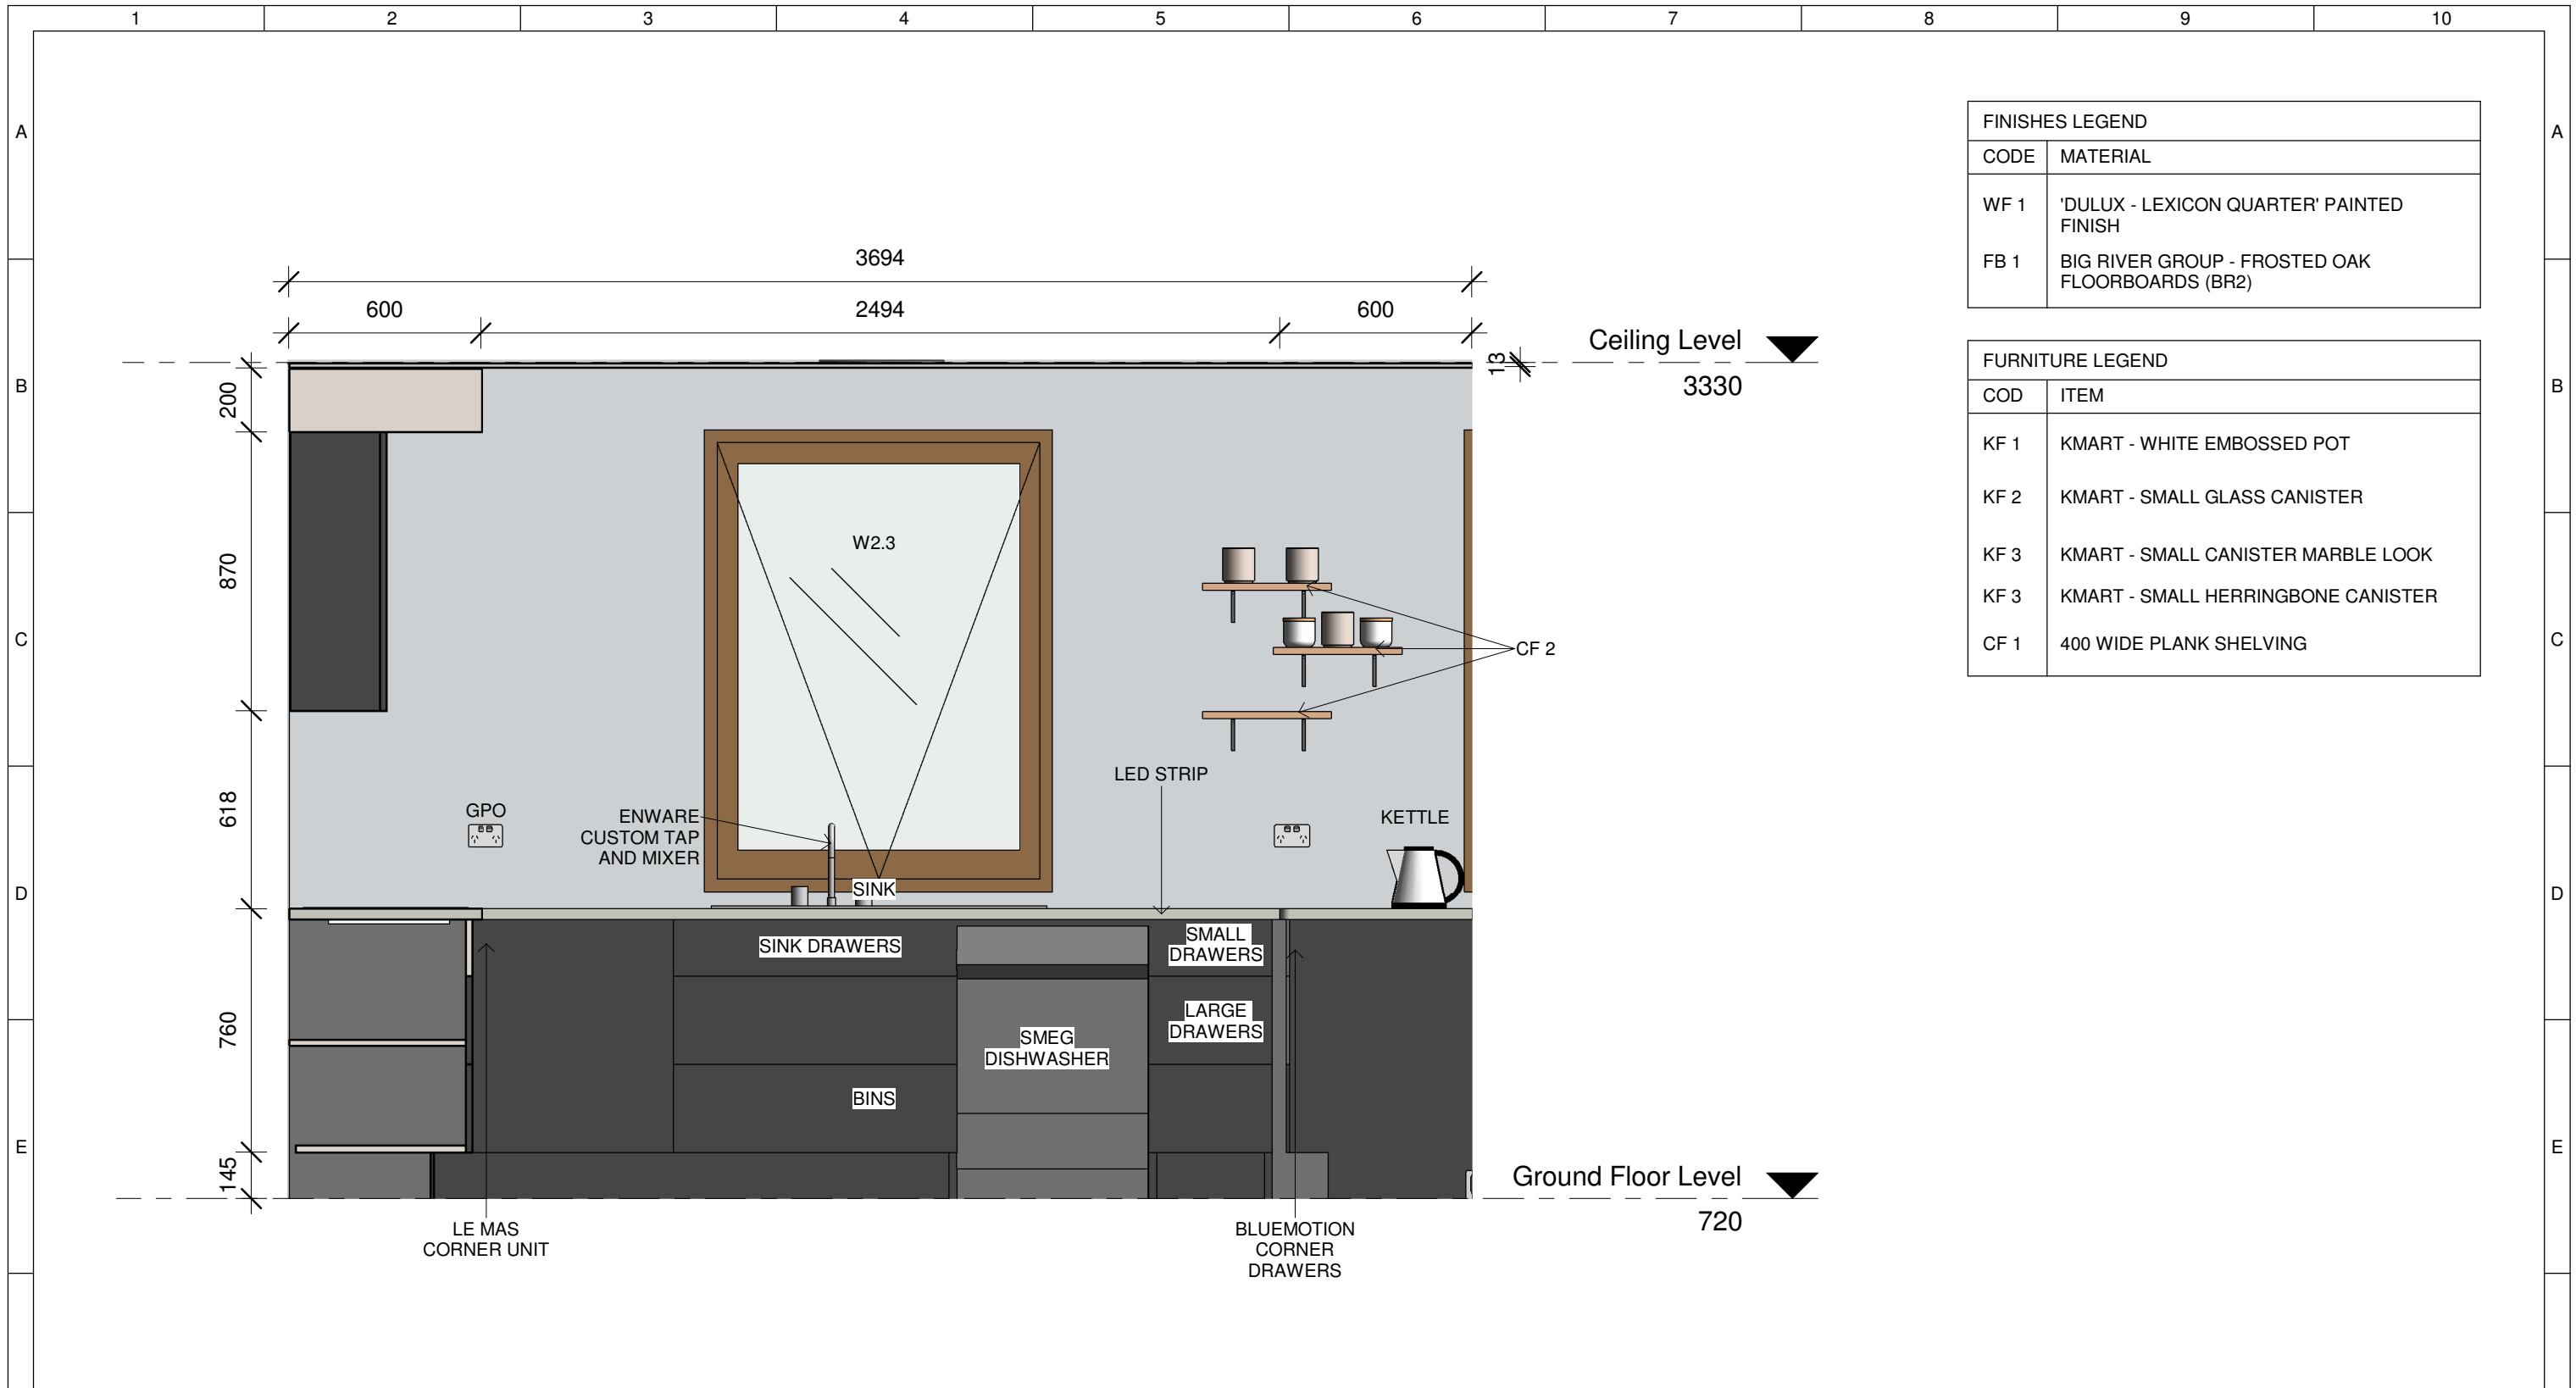


FINISHES LEGEND	
CODE	MATERIAL
WF 1	'DULUX - LEXICON QUARTER' PAINTED FINISH
FB 1	BIG RIVER GROUP - FROSTED OAK FLOORBOARDS (BR2)

FURNITURE LEGEND	
COD	ITEM
KF 1	KMART - WHITE EMBOSSED POT
KF 2	KMART - SMALL GLASS CANISTER
KF 3	KMART - SMALL CANISTER MARBLE LOOK
KF 3	KMART - SMALL HERRINGBONE CANISTER
CF 1	400 WIDE PLANK SHELVING


1 Kitchen Elevation - South
1 : 20

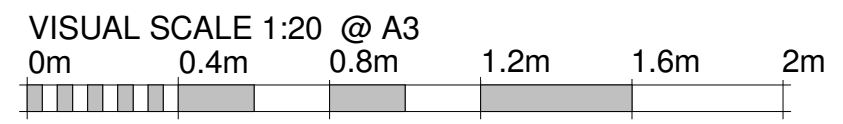


	Team: TEAM UOW Address: UNIVERSITY OF WOLLONGONG WOLLONGONG NSW, AUSTRALIA 2522 Contact: sd-2018@uow.edu.au www.desertrosehouse.com.au	Client: Dubai Electricity and Water Authority 	AMENDMENTS <table border="1"> <thead> <tr> <th>REV.</th> <th>DESCRIPTION</th> <th>DATE</th> <th>DRAWN</th> <th>CHECK</th> </tr> </thead> <tbody> <tr> <td>1</td> <td>Updated to As-Built</td> <td>14/09/18</td> <td>C</td> <td>VP</td> </tr> </tbody> </table>	REV.	DESCRIPTION	DATE	DRAWN	CHECK	1	Updated to As-Built	14/09/18	C	VP	COPYRIGHT None; Project is Public LOT # M DRAWER V.PHAM CHECKED J.ROTH DATE 20 February, 2018 SCALE 1 : 20 @ A3	KITCHEN ELEVATION -NORTH IN-412 SHEET: 01 OF 01
	REV.	DESCRIPTION	DATE	DRAWN	CHECK										
	1	Updated to As-Built	14/09/18	C	VP										

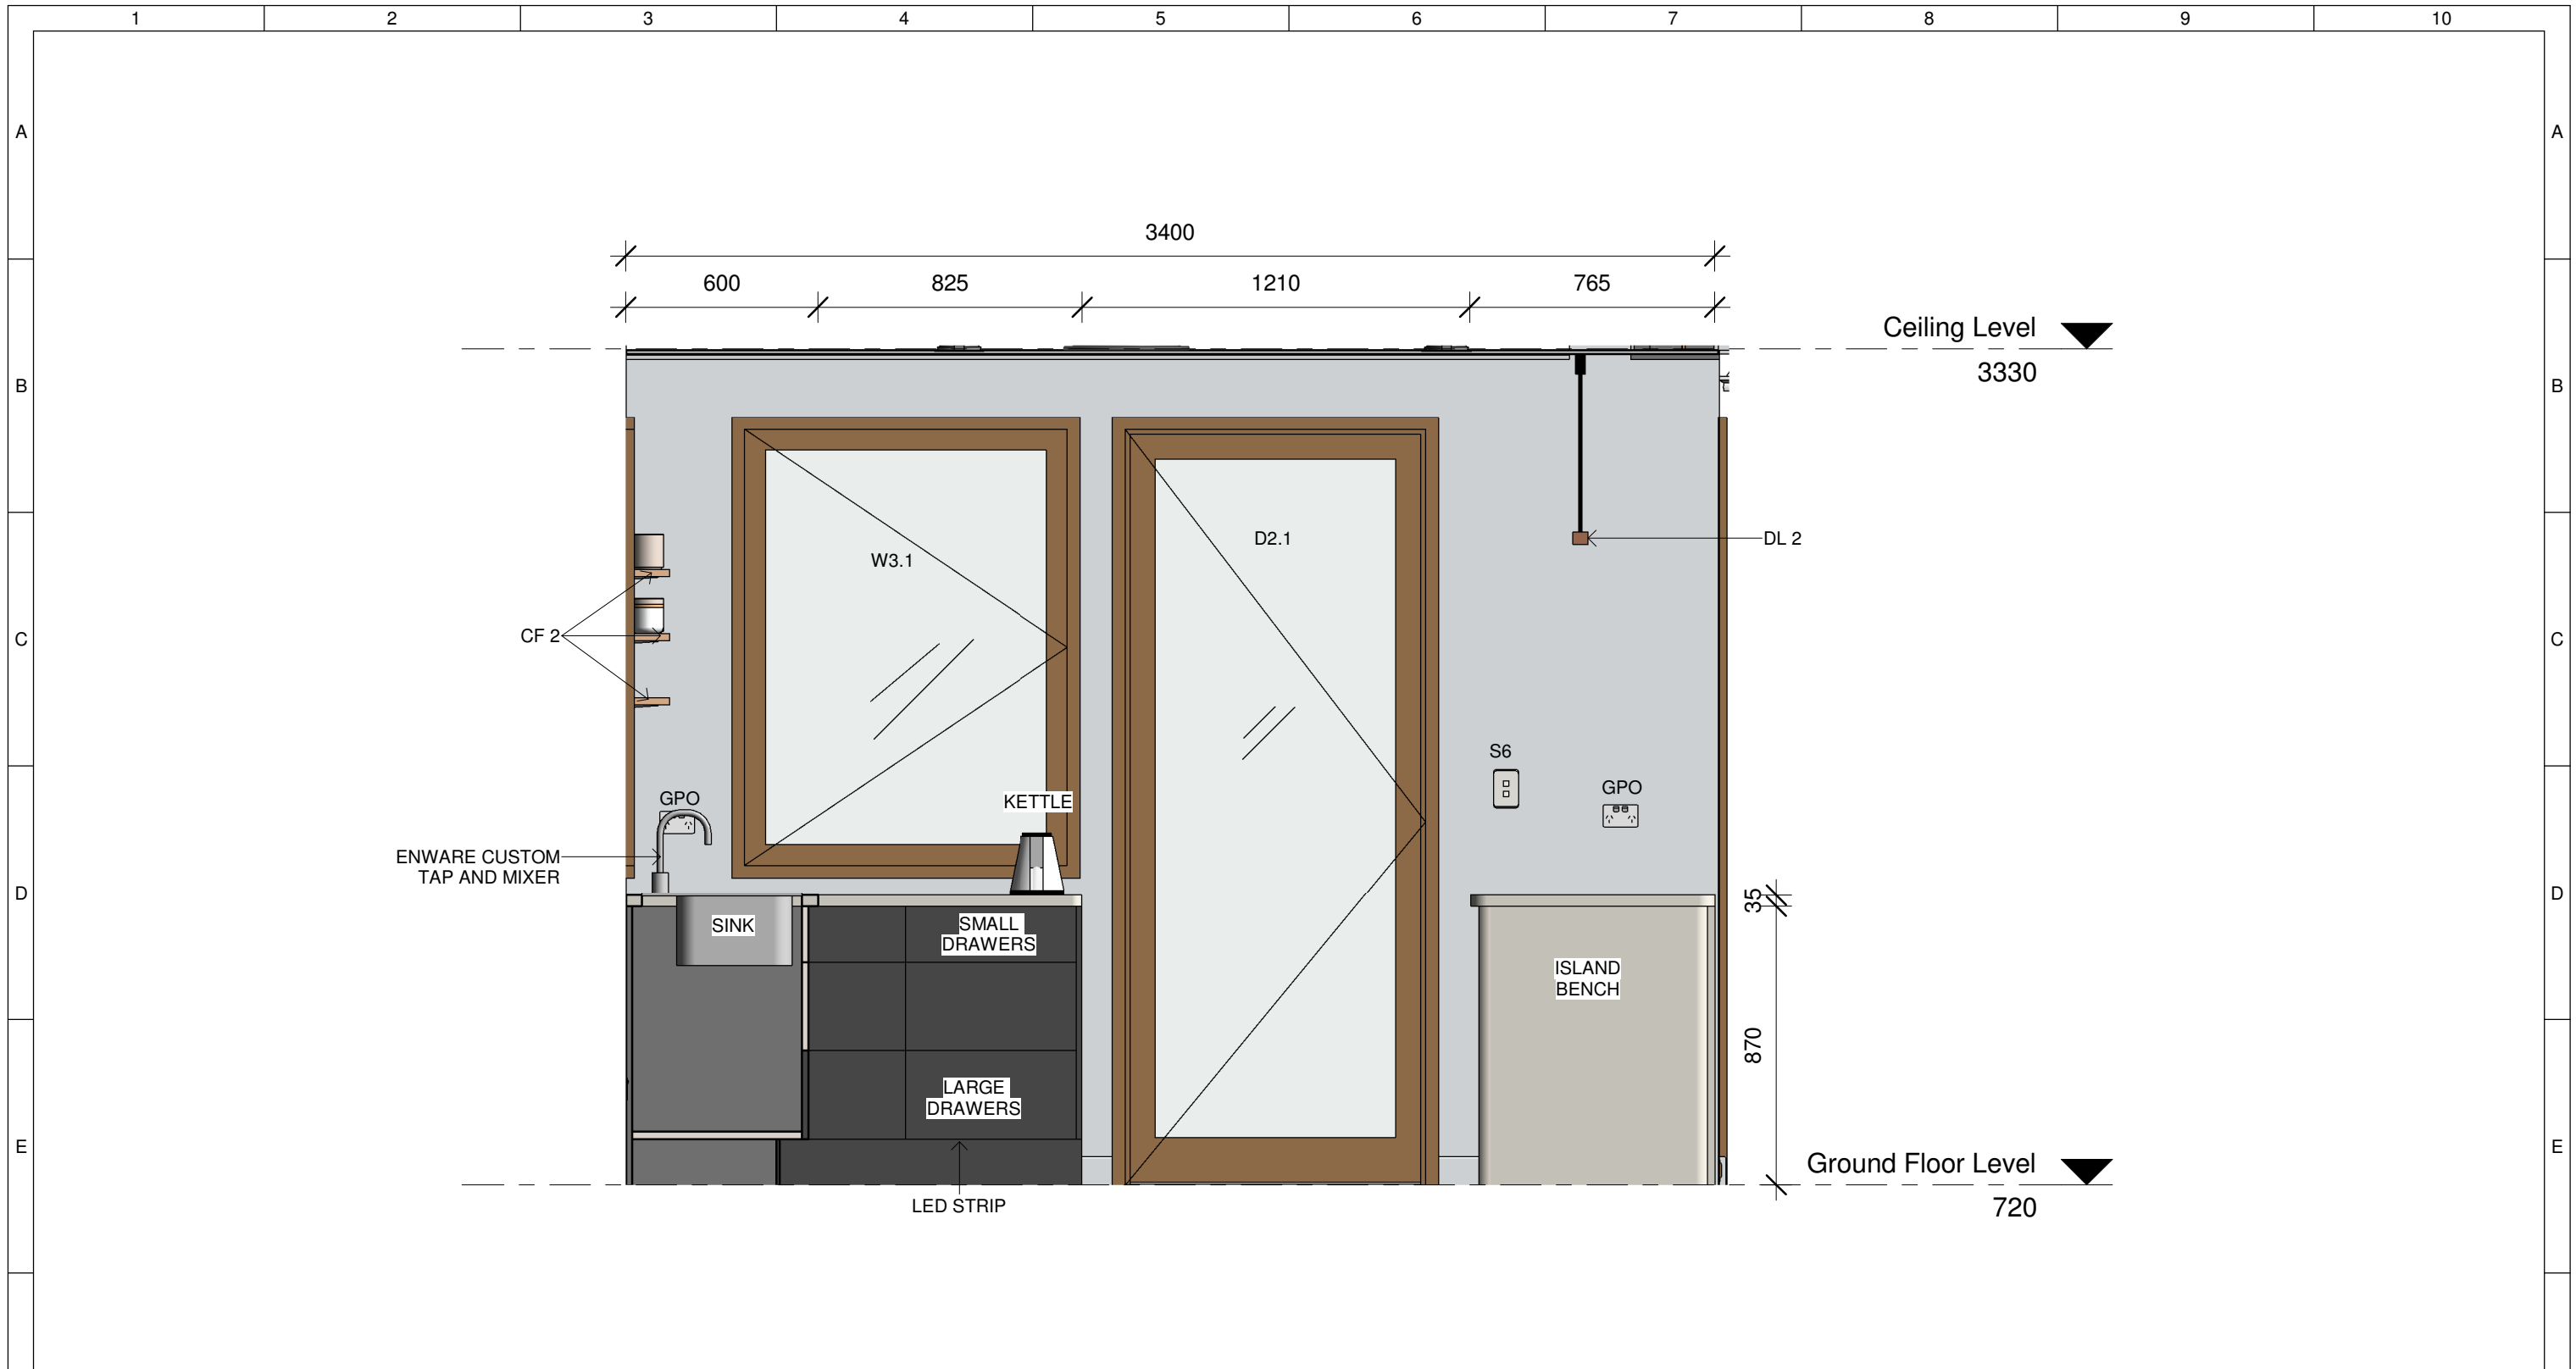

1 Kitchen Elevation - West
1 : 20

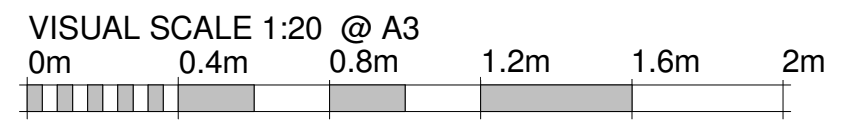

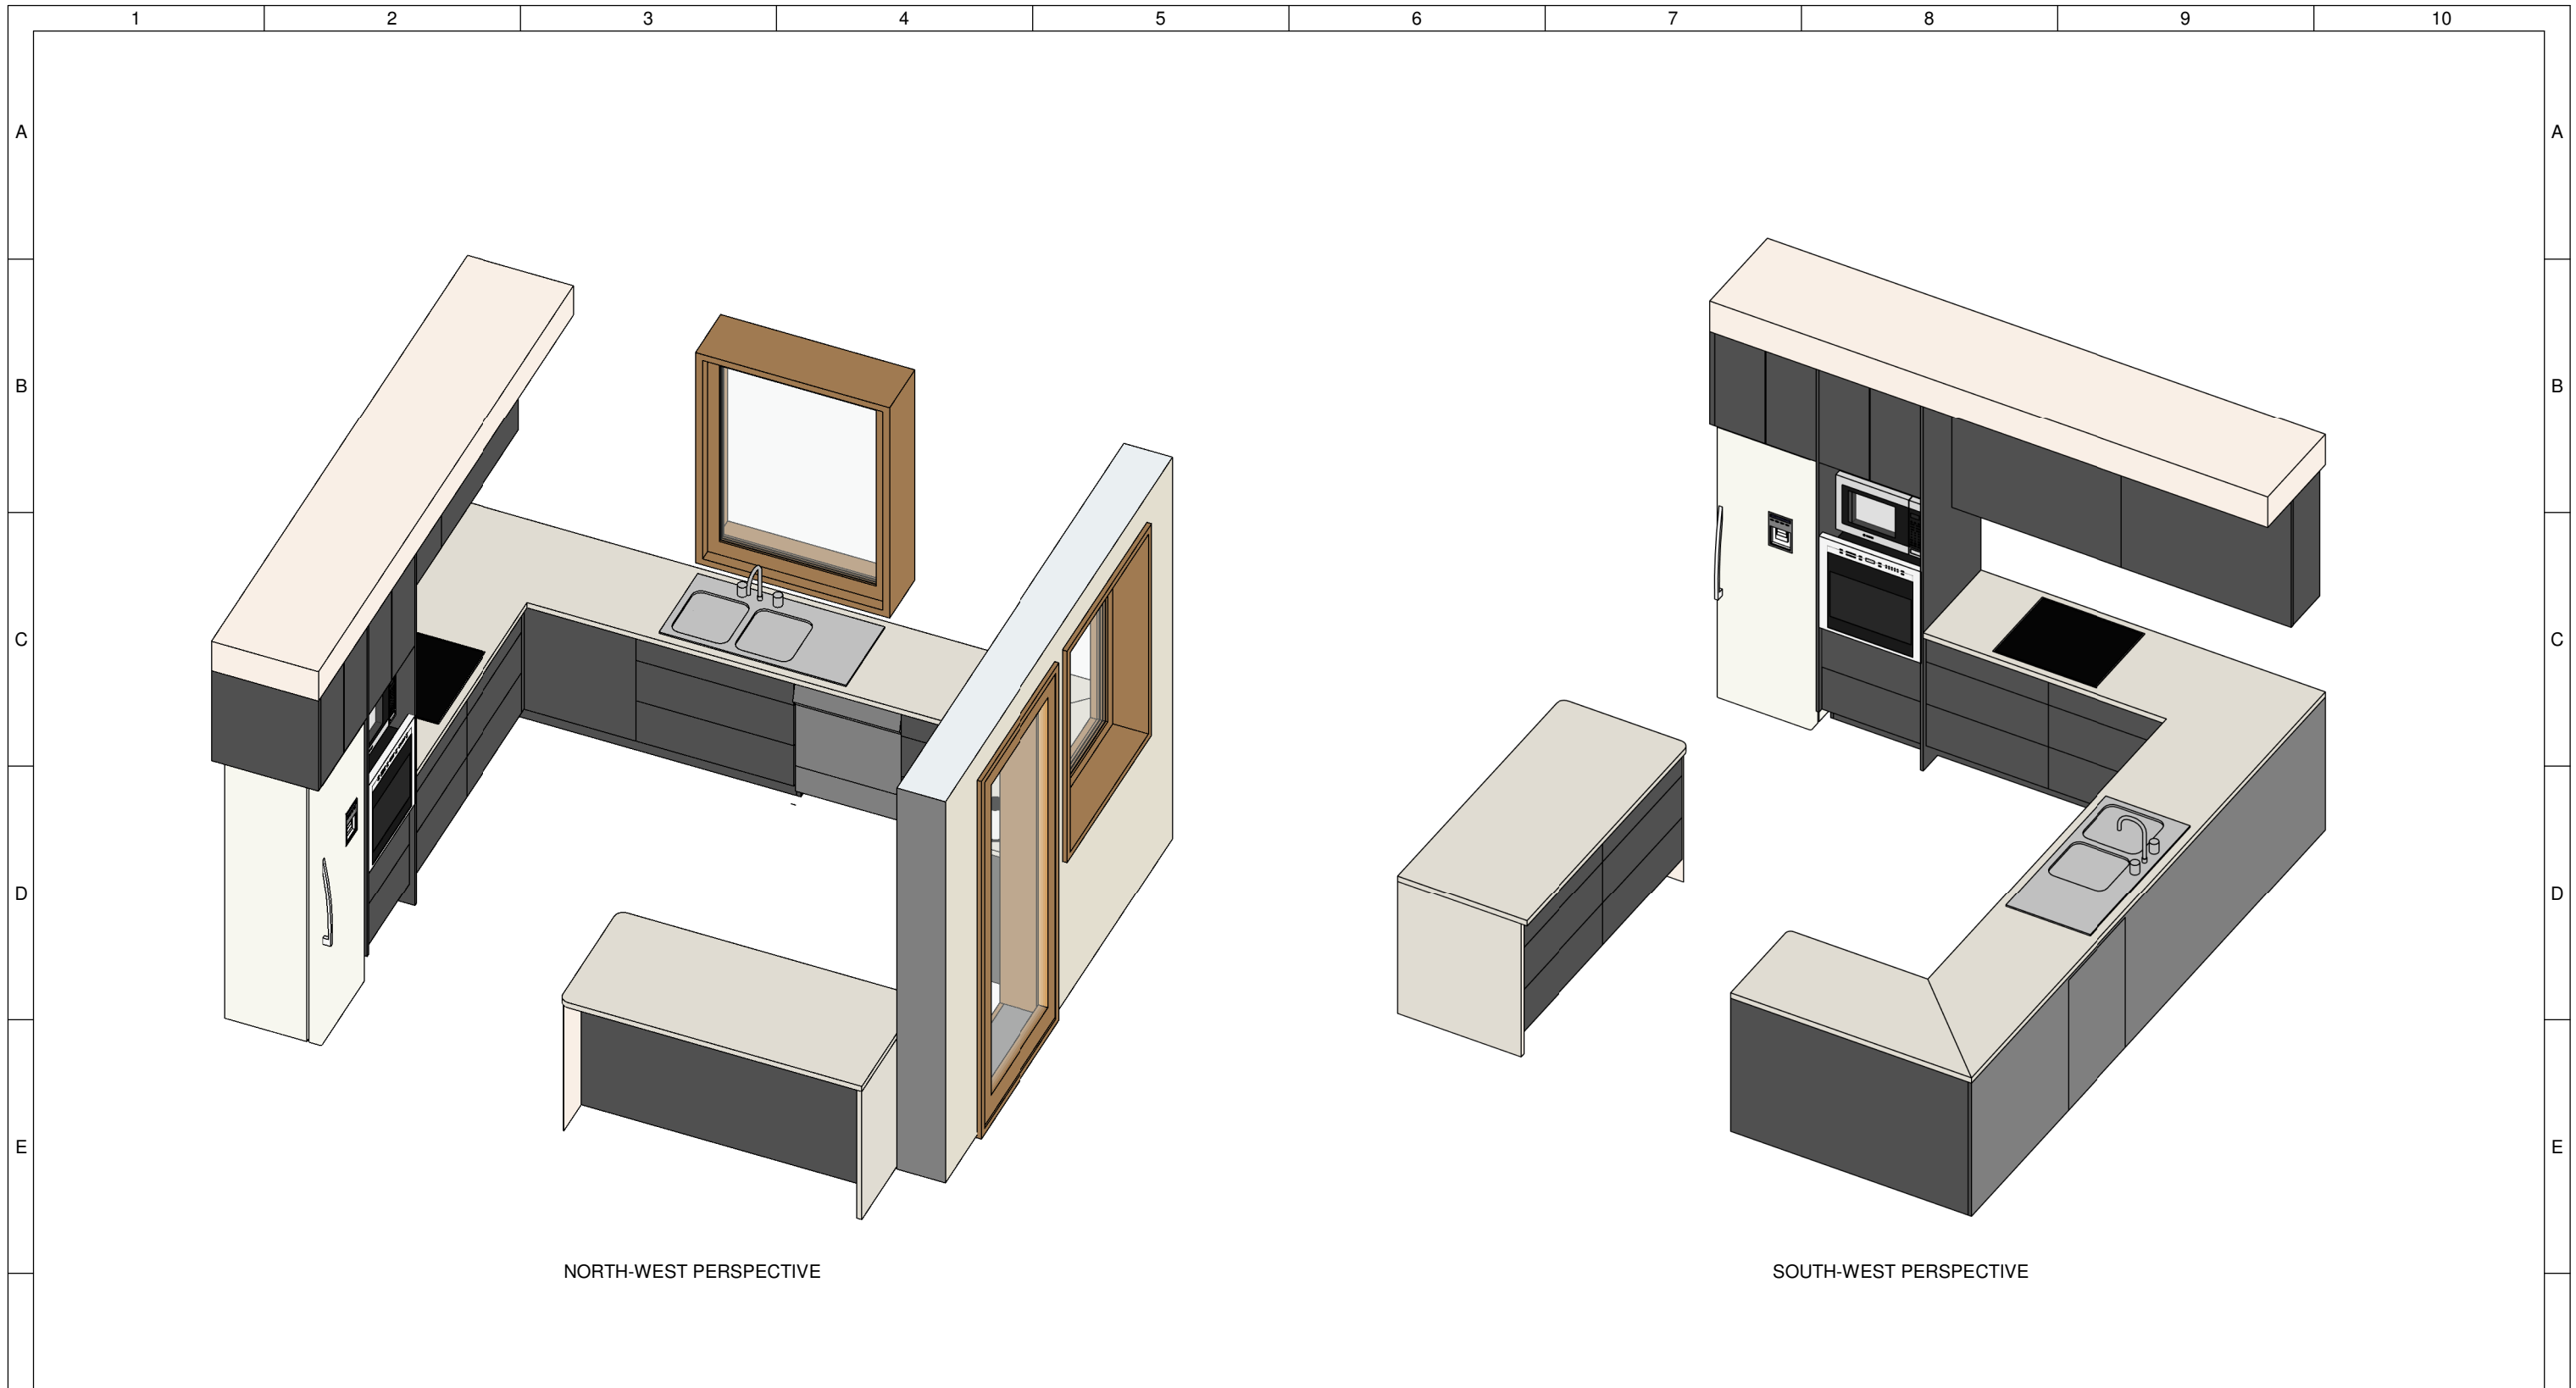


	Team: TEAM UOW Address: UNIVERSITY OF WOLLONGONG WOLLONGONG NSW, AUSTRALIA 2522	Client: Dubai Electricity and Water Authority 	AMENDMENTS				COPYRIGHT None; Project is Public		KITCHEN ELEVATION - EAST IN-413														
	Contact: sd-2018@uow.edu.au www.desertrosehouse.com.au		<table border="1"> <thead> <tr> <th>REV.</th> <th>DESCRIPTION</th> <th>DATE</th> <th>DRAWN</th> <th>CHECK</th> </tr> </thead> <tbody> <tr> <td>1</td> <td>Updated to As-Built</td> <td>14/09/18</td> <td>C</td> <td>VP</td> </tr> </tbody> </table>	REV.	DESCRIPTION	DATE	DRAWN	CHECK		1	Updated to As-Built	14/09/18	C	VP	<table border="1"> <thead> <tr> <th>LOT</th> <th># M</th> </tr> </thead> <tbody> <tr> <td>DRAWER</td> <td>V.PHAM</td> </tr> <tr> <td>CHECKED</td> <td>J. ROTH</td> </tr> <tr> <td>DATE</td> <td>20 February, 2018</td> </tr> <tr> <td>SCALE</td> <td>1 : 20 @ A3</td> </tr> </tbody> </table>	LOT	# M	DRAWER	V.PHAM	CHECKED	J. ROTH	DATE	20 February, 2018
REV.	DESCRIPTION	DATE	DRAWN	CHECK																			
1	Updated to As-Built	14/09/18	C	VP																			
LOT	# M																						
DRAWER	V.PHAM																						
CHECKED	J. ROTH																						
DATE	20 February, 2018																						
SCALE	1 : 20 @ A3																						




NORTH-WEST PERSPECTIVE

SOUTH-WEST PERSPECTIVE

1 Kitchen 3D

 <p>Desert Rose Team UOW Australia - Dubai</p>	<p>Team: TEAM UOW</p>	<p>Client:</p>  <p>Dubai Electricity and Water Authority</p> 	<p>AMENDMENTS</p> <table border="1"> <thead> <tr> <th>REV.</th> <th>DESCRIPTION</th> <th>DATE</th> <th>DRAWN</th> <th>CHECK</th> </tr> </thead> <tbody> <tr> <td>1</td> <td>Updated to As-Built</td> <td>14/09/1</td> <td>VP</td> <td>JR</td> </tr> </tbody> </table>				REV.	DESCRIPTION	DATE	DRAWN	CHECK	1	Updated to As-Built	14/09/1	VP	JR	<p>COPYRIGHT</p> <p>None; Project is Public</p>		<p>ISOMETRIC KITCHEN VIEWS</p>
	REV.		DESCRIPTION	DATE	DRAWN	CHECK													
1	Updated to As-Built	14/09/1	VP	JR															
<p>Address: UNIVERSITY OF WOLLONGONG WOLLONGONG NSW, AUSTRALIA 2522</p>	<p>Contact: sd-2018@uow.edu.au www.desertrosehouse.com.au</p>	<p>LOT # M</p> <p>DRAWER J.ROTH</p> <p>CHECKED V.PHAM</p> <p>DATE 20 April, 2018</p> <p>SCALE NTS @ A3</p>	<p>SHEET: 01 OF 01</p>	<p>IN-414</p>															

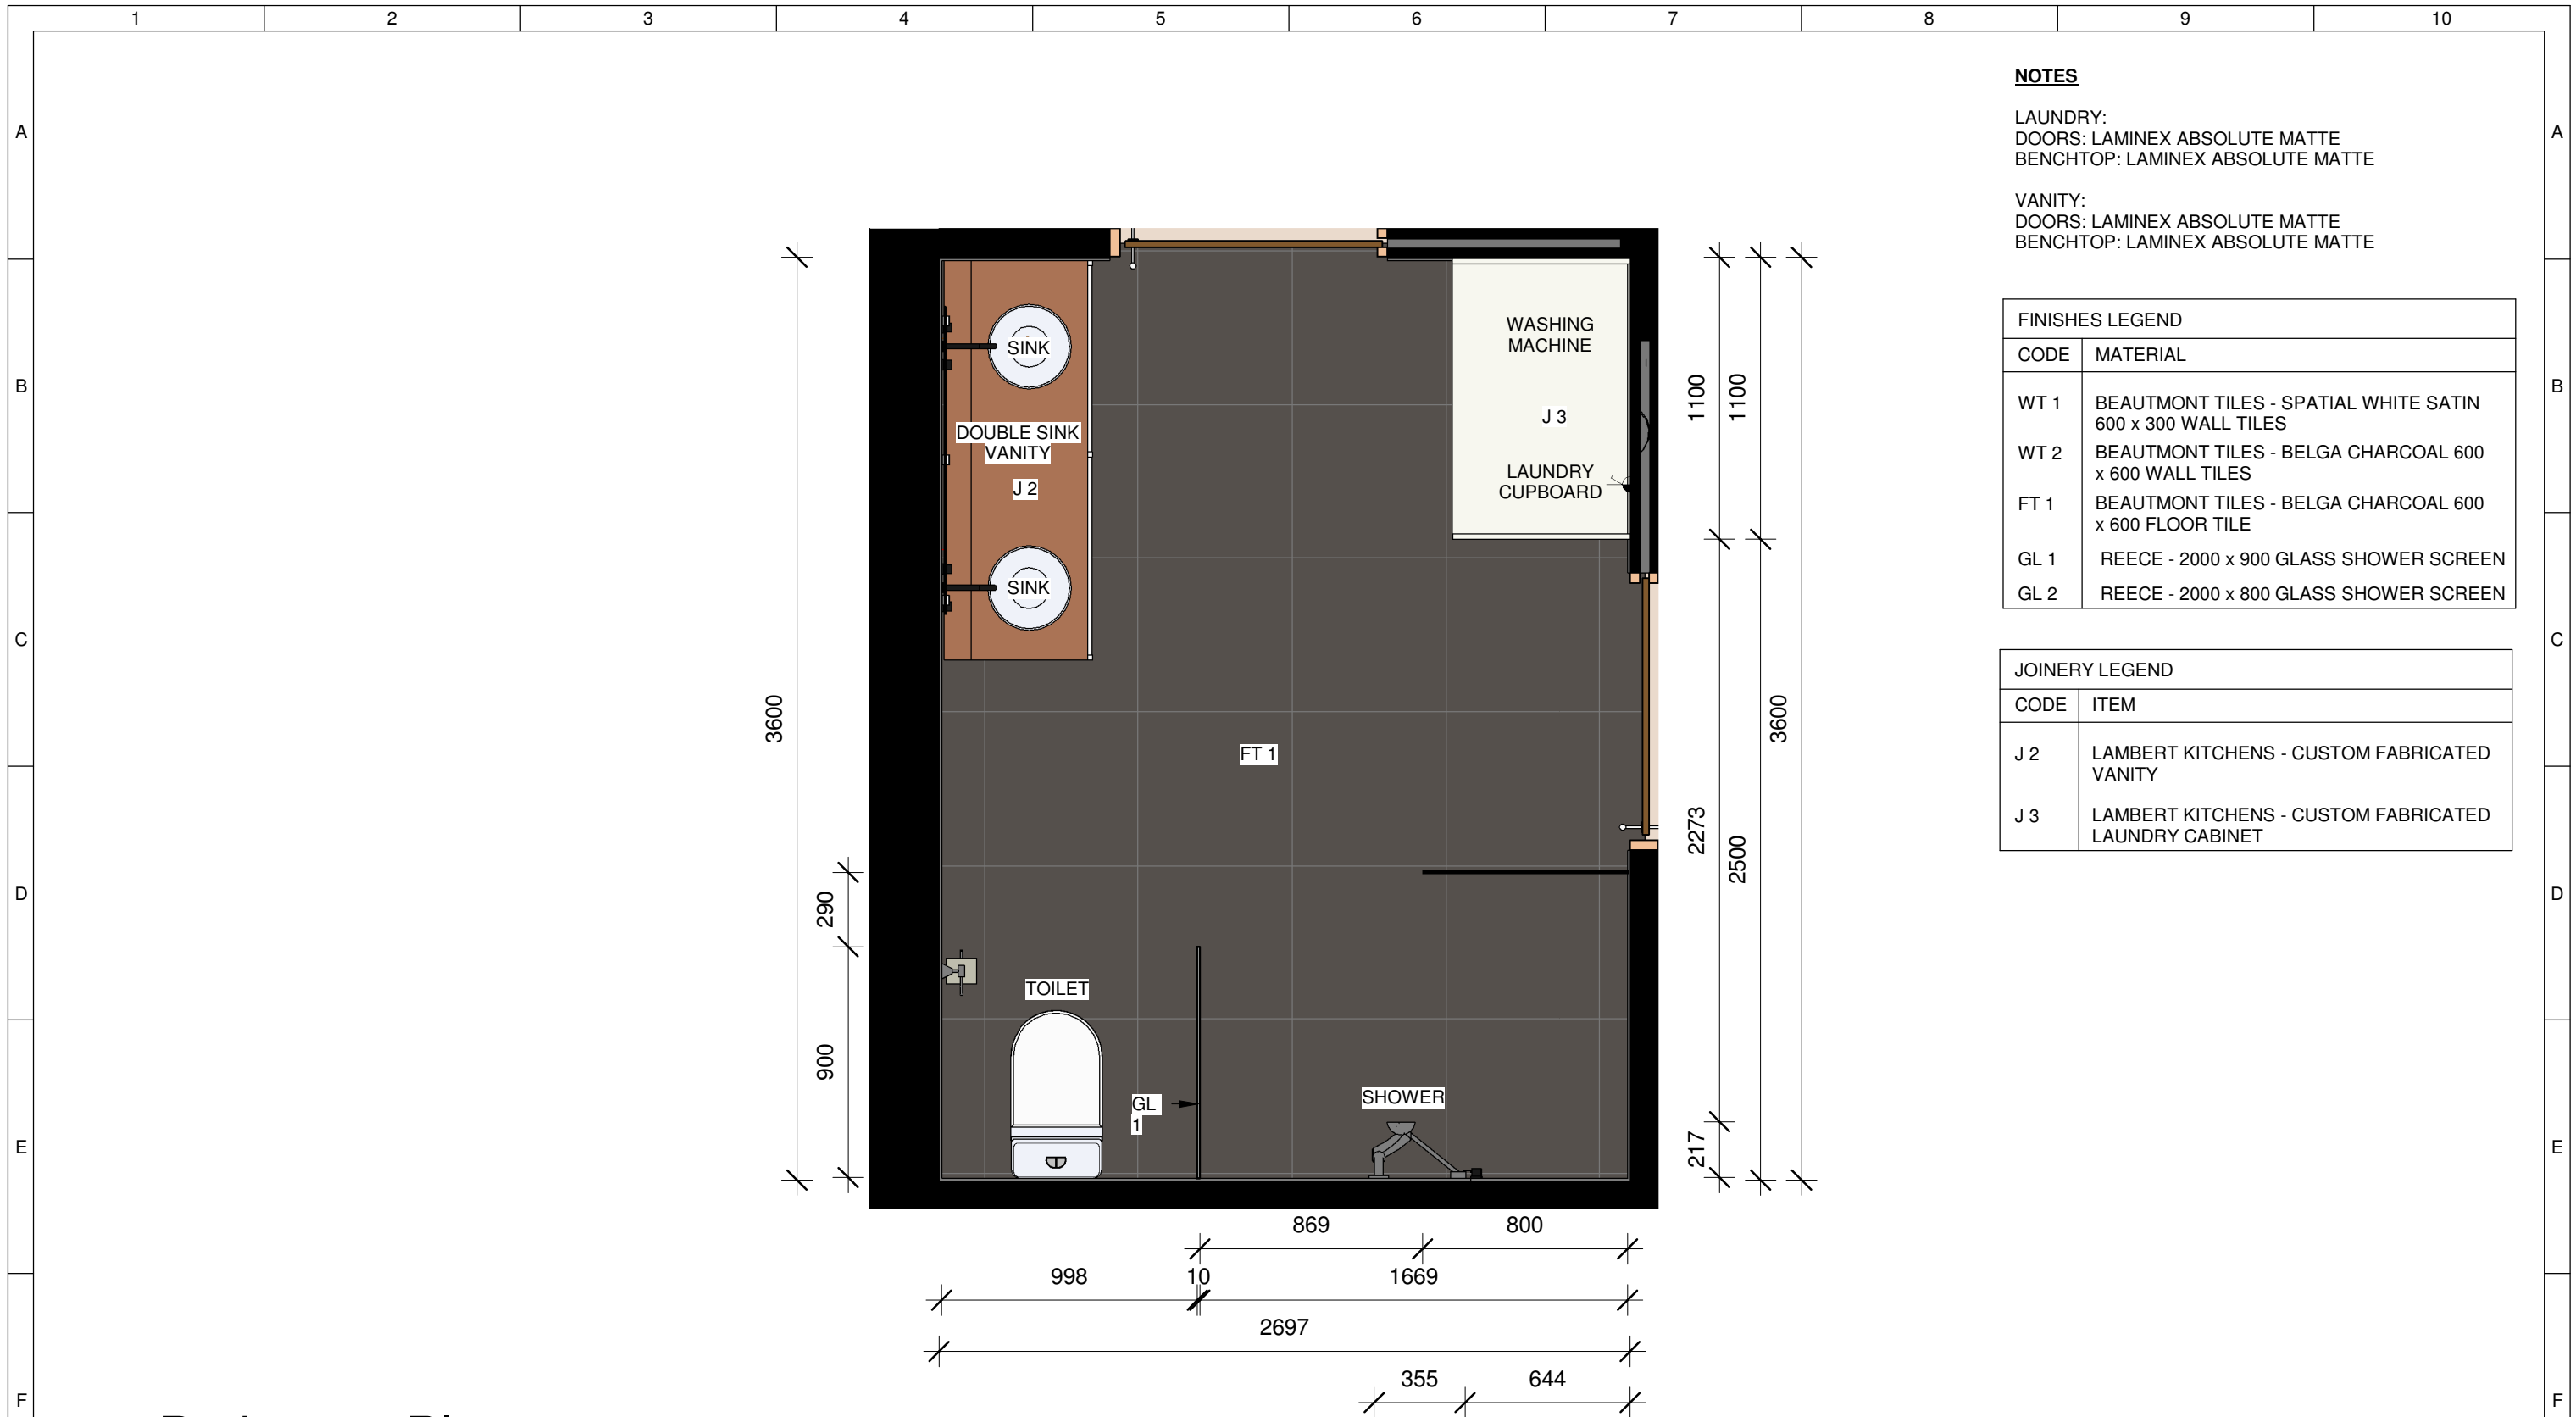

NOTES

LAUNDRY:
DOORS: LAMINEX ABSOLUTE MATTE
BENCHTOP: LAMINEX ABSOLUTE MATTE


VANITY:
DOORS: LAMINEX ABSOLUTE MATTE
BENCHTOP: LAMINEX ABSOLUTE MATTE

FINISHES LEGEND	
CODE	MATERIAL
WT 1	BEAUMONT TILES - SPATIAL WHITE SATIN 600 x 300 WALL TILES
WT 2	BEAUMONT TILES - BELGA CHARCOAL 600 x 600 WALL TILES
FT 1	BEAUMONT TILES - BELGA CHARCOAL 600 x 600 FLOOR TILE
GL 1	REECE - 2000 x 900 GLASS SHOWER SCREEN
GL 2	REECE - 2000 x 800 GLASS SHOWER SCREEN


JOINERY LEGEND	
CODE	ITEM
J 2	LAMBERT KITCHENS - CUSTOM FABRICATED VANITY
J 3	LAMBERT KITCHENS - CUSTOM FABRICATED LAUNDRY CABINET

Bathroom Plan

 1 : 25




	Team: TEAM UOW Address: UNIVERSITY OF WOLLONGONG WOLLONGONG NSW, AUSTRALIA 2522 Contact: sd-2018@uow.edu.au www.desertrosehouse.com.au	Client: Dubai Electricity and Water Authority 	AMENDMENTS <table border="1"> <thead> <tr> <th>REV.</th> <th>DESCRIPTION</th> <th>DATE</th> <th>DRAWN</th> <th>CHECK</th> </tr> </thead> <tbody> <tr> <td>1</td> <td>Updated Plans, Detailing and Template Adjustments</td> <td>01/02/18</td> <td>JR</td> <td>VP</td> </tr> <tr> <td>2</td> <td>Updated to As-Built</td> <td>14/09/1</td> <td>CE</td> <td>VP</td> </tr> </tbody> </table>	REV.	DESCRIPTION	DATE	DRAWN	CHECK	1	Updated Plans, Detailing and Template Adjustments	01/02/18	JR	VP	2	Updated to As-Built	14/09/1	CE	VP	COPYRIGHT None; Project is Public LOT # M DRAWER J. ROTH CHECKED V. PHAM DATE 20 February, 2018 SCALE 1 : 25 @ A3	<p>BATHROOM PLAN</p> <p>SHEET: 01 OF 01</p> <p>IN-501</p>
	REV.	DESCRIPTION	DATE	DRAWN	CHECK															
1	Updated Plans, Detailing and Template Adjustments	01/02/18	JR	VP																
2	Updated to As-Built	14/09/1	CE	VP																

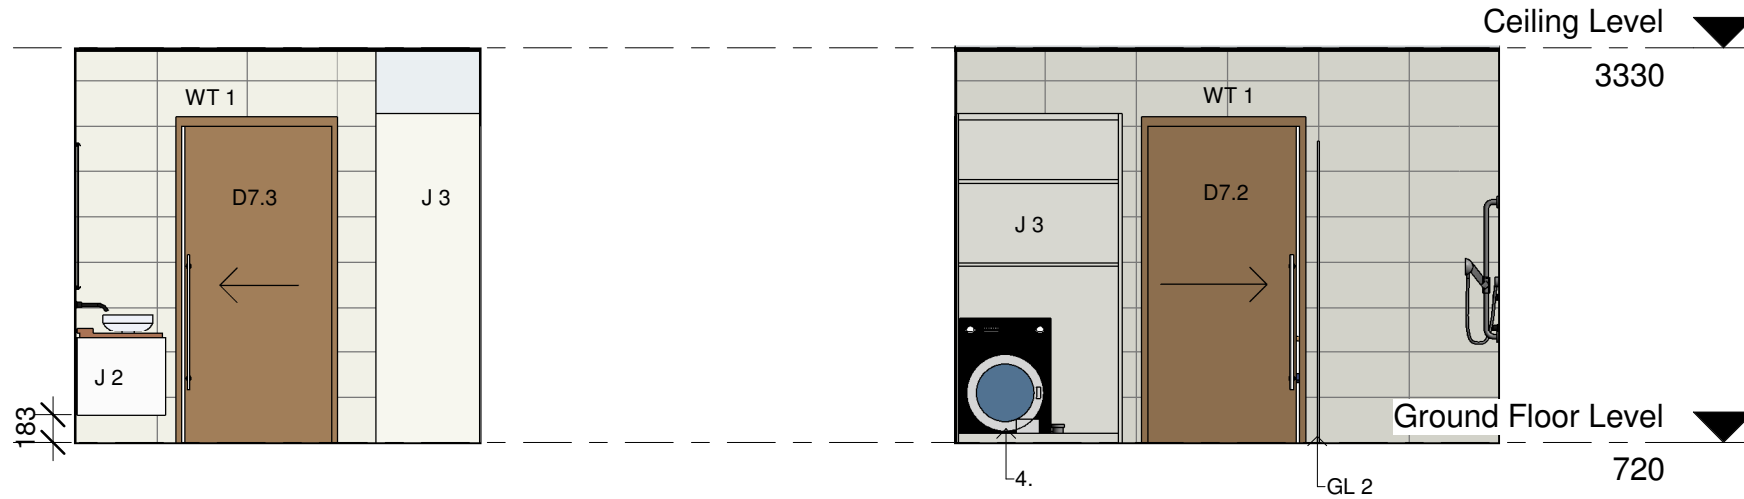

1 Bathroom - North
1 : 50

3 Bathroom - East
1 : 50

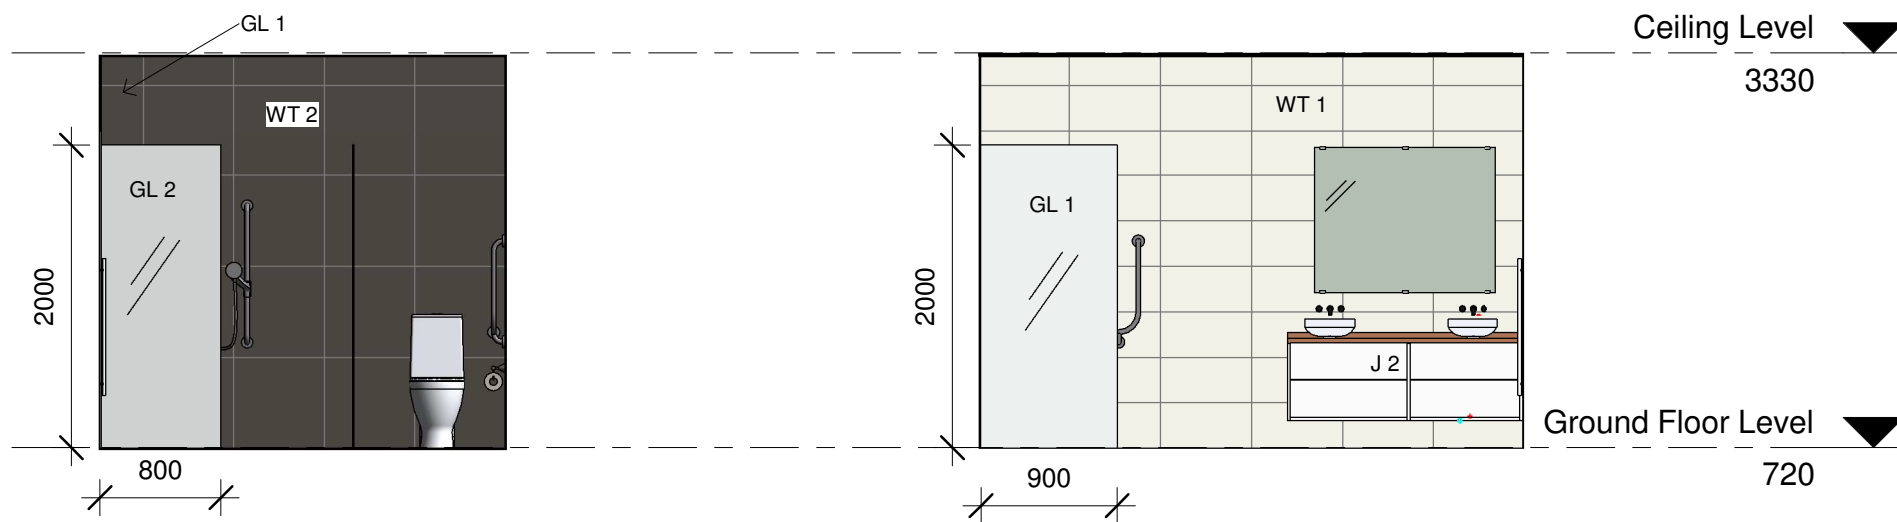


2 Bathroom - South
1 : 50

4 Bathroom - West
1 : 50

FINISHES LEGEND	
CODE	MATERIAL
WT 1	BEAUMONT TILES - SPATIAL WHITE SATIN 600 x 300 WALL TILES
WT 2	BEAUMONT TILES - BELGA CHARCOAL 600 x 600 WALL TILES
FT 1	BEAUMONT TILES - BELGA CHARCOAL 600 x 600 FLOOR TILE
GL 1	REECE - 2000 x 900 GLASS SHOWER SCREEN
GL 2	REECE - 2000 x 800 GLASS SHOWER SCREEN

JOINERY LEGEND	
CODE	ITEM
J 2	LAMBERT KITCHENS - CUSTOM FABRICATED DOUBLE SINK VANITY
J 3	LAMBERT KITCHENS - CUSTOM FABRICATED LAUNDRY CABINET

NOTE
FOR CLOTHES WASHER DETAILS REFER TO ID-005

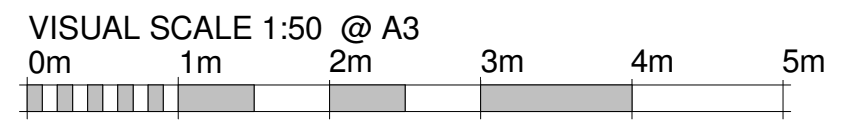


Team: TEAM UOW
Address: UNIVERSITY OF WOLLONGONG
 WOLLONGONG
 NSW, AUSTRALIA 2522
Contact: sd-2018@uow.edu.au
 www.desertrosehouse.com.au

Client: Dubai Electricity and Water Authority
SOLAR DECATHLON MIDDLE EAST DUBAI, UAE - 2018

AMENDMENTS					
REV.	DESCRIPTION	DATE	DRAWN	CHECK	
1	Included Legend and updated detailing	09/09/18	CE	VP	
2	Updated to As-Built	14/09/1	CE	VP	


COPYRIGHT	
None; Project is Public	
LOT	# M
DRAWER	M. PHAN
CHECKED	V. PHAM
DATE	20 February, 2018
SCALE	1 : 50 @ A3

BATHROOM ELEVATIONS AND FINISHES
IN-511
 SHEET: 01 OF 01

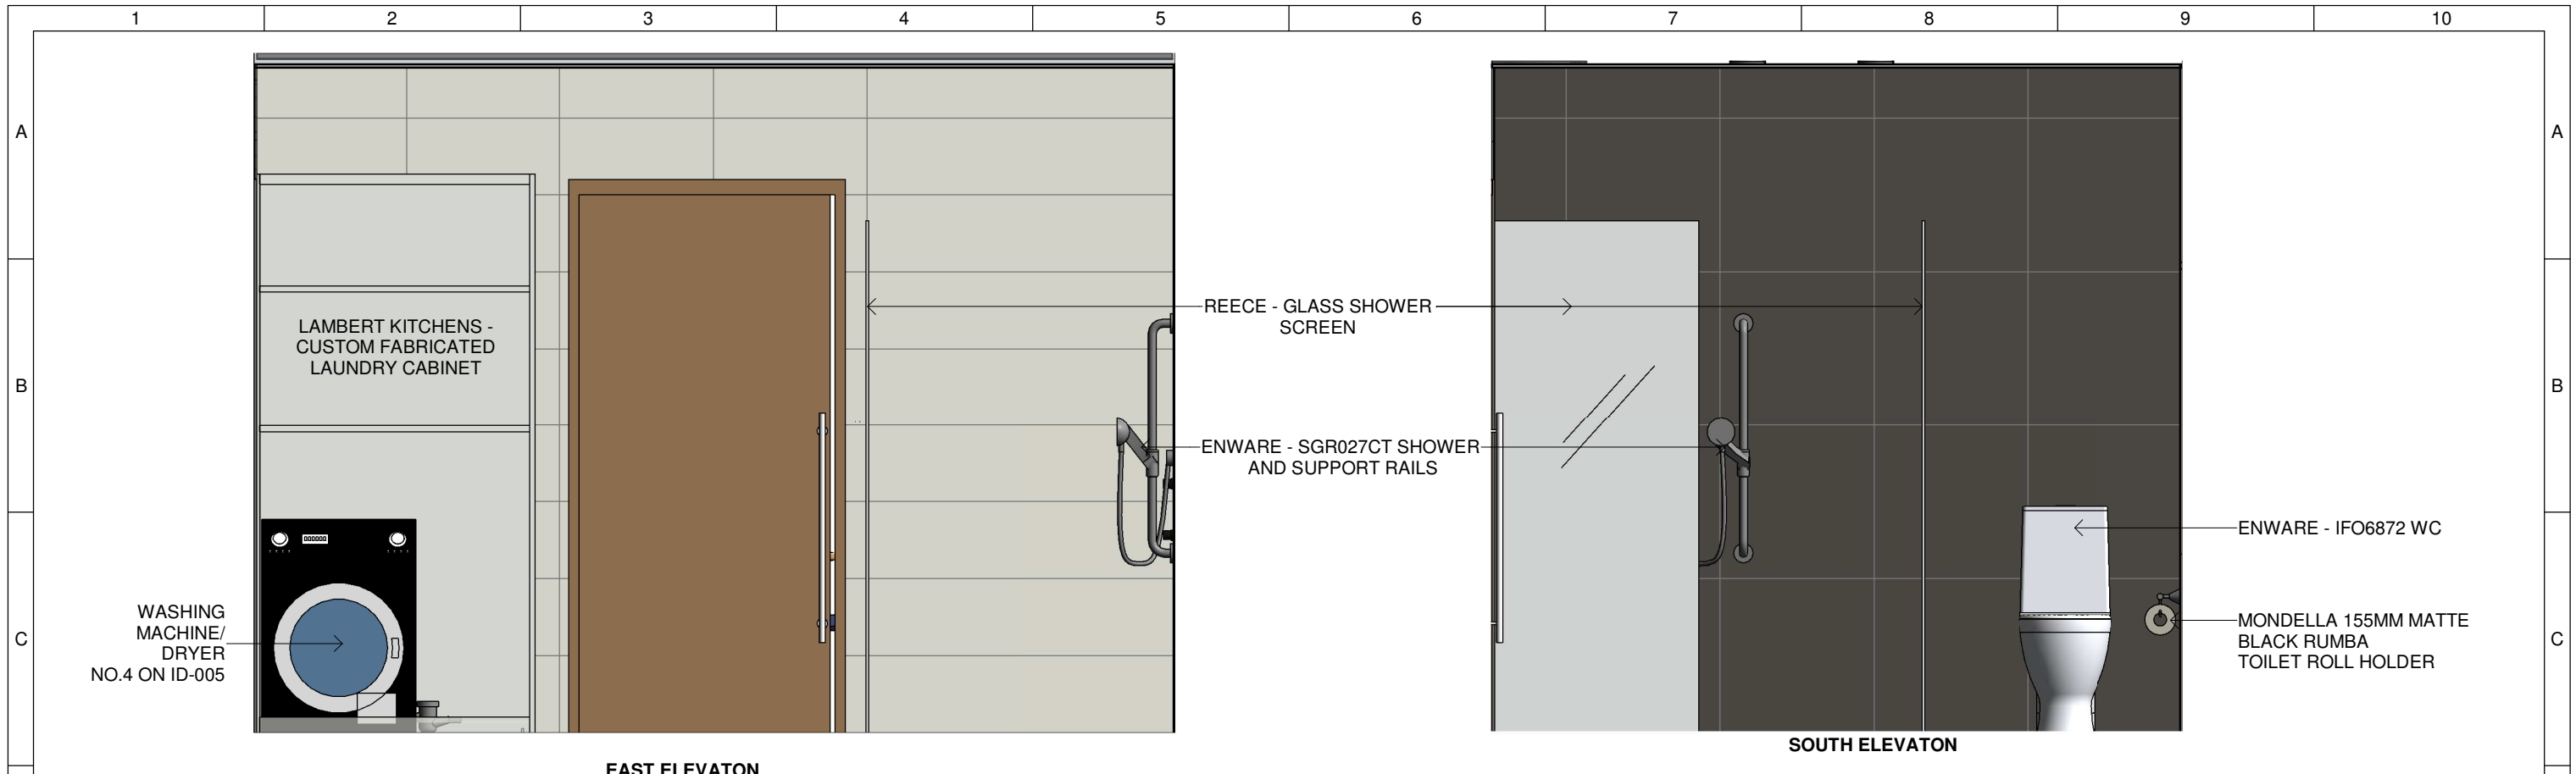

EAST ELEVATION

SOUTH ELEVATION

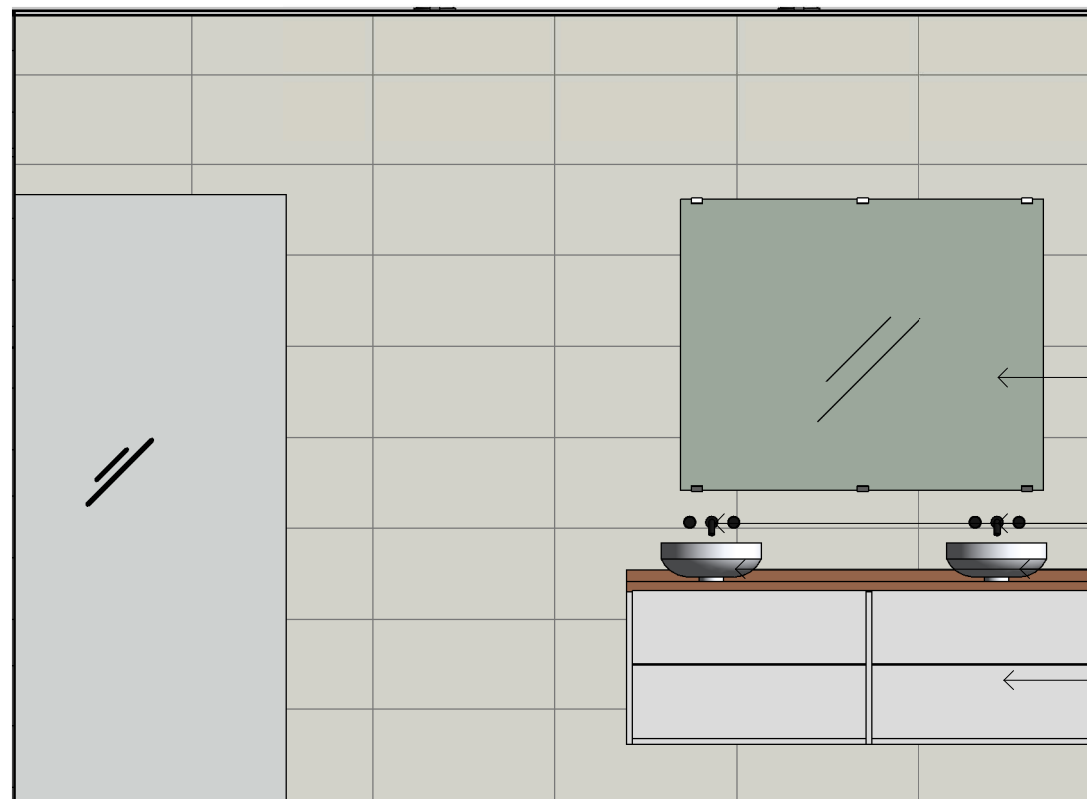

WEST ELEVATION

 
IKEA - GODMORGON 120 X 96 MIRROR

ENWARE CUSTOM TAP AND MIXER

REECE - VENICE 450 SOLID SURFACE COUNTER BASIN WHITE

LAMBERT KITCHENS - CUSTOM FABRICATED VANITY

VISUAL SCALE 1:25 @ A3



1 Bathroom Elevations

1 : 25



Team: TEAM UOW
 Address: UNIVERSITY OF WOLLONGONG
 WOLLONGONG
 NSW, AUSTRALIA 2522
 Contact: sd-2018@uow.edu.au
 www.desertrosehouse.com.au




AMENDMENTS						
REV.	DESCRIPTION	DATE	DRAWN	CHECK		
1	Included Legend and updated detailing	12/09/1	CE	VP		
2	Updated to As-Built	14/09/1	CE	VP		

COPYRIGHT	
None; Project is Public	
LOT	# M
DRAWER	J. PERERAGE
CHECKED	V. PHAM
DATE	20 February, 2018
SCALE	1 : 25 @ A3

SHEET:
01 OF 01

BATHROOM ELEVATIONS AND FIXTURES

IN-512

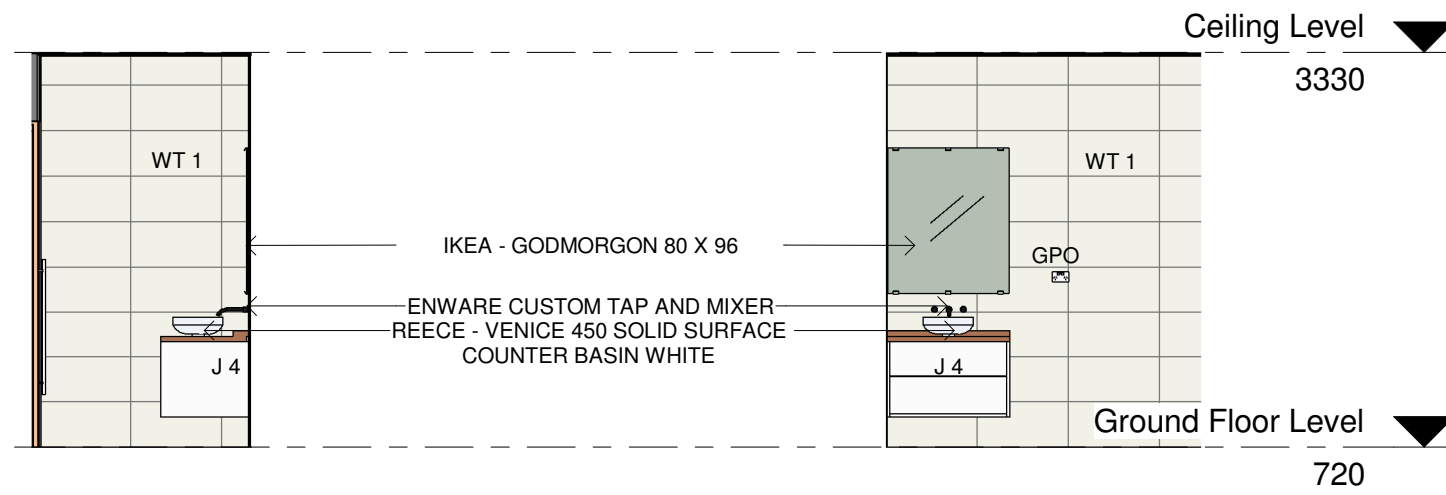


FINISHES LEGEND	
CODE	MATERIAL
WT 1	BEAUMONT TILES - SPATIAL WHITE SATIN 600 x 300 WALL TILES
WT 2	BEAUMONT TILES - BELGA CHARCOAL 600 x 600 WALL TILES
FT 1	BEAUMONT TILES - BELGA CHARCOAL 600 x 600 FLOOR TILE

JOINERY LEGEND	
CODE	ITEM
J 4	LAMBERT KITCHENS - CUSTOM FABRICATED SINGLE SINK VANITY

1 W.C. - North
1 : 50

2 W.C. - East
1 : 50

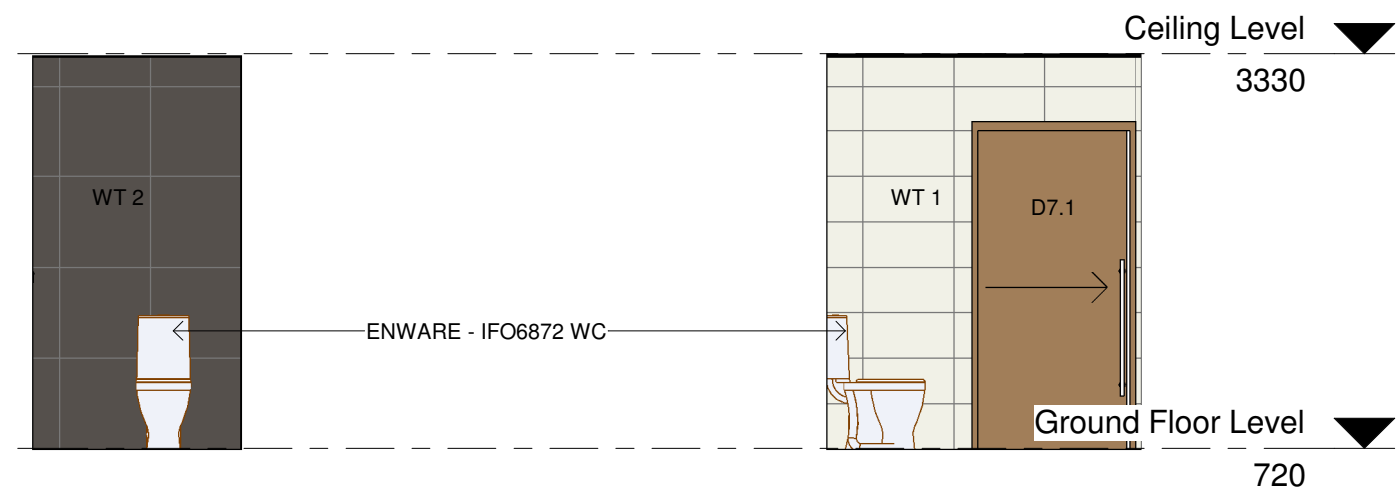

3 W.C. - South
1 : 50

4 W.C. - West
1 : 50



Team: TEAM UOW
Address: UNIVERSITY OF WOLLONGONG WOLLONGONG NSW, AUSTRALIA 2522
Contact: sd-2018@uow.edu.au www.desertrosehouse.com.au

Client: Dubai Electricity and Water Authority
SOLAR DECATHLON MIDDLE EAST DUBAI, UAE - 2018

AMENDMENTS			
REV.	DESCRIPTION	DATE	DRAWN CHECK
1	Updated to As-Built	14/09/1	CE VP

COPYRIGHT	
None; Project is Public	
LOT	# M
DRAWER	C.EIO
CHECKED	V.PHAM
DATE	12 September,
SCALE	1 : 50 @ A3



W.C. ELEVATIONS
SHEET: 01 OF 01
IN-513



1 Living Room Render
NTS



2 Dining Room Render
NTS

 Desert Rose Team UOW Australia - Dubai	Team: TEAM UOW Address: UNIVERSITY OF WOLLONGONG WOLLONGONG NSW, AUSTRALIA 2522	Client: Dubai Electricity and Water Authority 	AMENDMENTS REV. DESCRIPTION DATE DRAWN CHECK			COPYRIGHT None; Project is Public LOT # M DRAWER L.FAIDUTTI CHECKED C.MCDOWELL DATE 20 February, 2018 SCALE As indicated @ A3		INTERIOR RENDERINGS IN-601
	Contact: sd-2018@uow.edu.au www.desertrosehouse.com.au						SHEET: 01 OF 01	